

Note :-

- 1. BUILDING WILL BE DESIGNED (STRUCTURES) AS PER RELEVANT IS CODES FOR EARTH QUAKE RESISTANCE.
- 2. THE BUILDING IS ARTIFICIALLY LIT AND MECHANICALLY VENTILATED.

LEGEND :-

PROJECT :

REVISED BUILDING PLANS OF GROUP HOUSING COLONY AREA MEASURING 25.087 ACRES LICENCE NO. 123 OF 2012 DATED 20-12-2012 IN SECTOR-63, GURGAON, BEING DEVELOPED BY ARLE BUILDERS & DEVELOPERS PVT. LTD. AND OTHERS IN COLLABORATION WITH DLF HOME DEVELOPERS LTD (EARLIER KNOWN AS DLF NEW GURGAON HOME DEVELOPERS PVT. LTD)

ARCHITECTURE:

ARCOP

ARCOP ASSOCIATES PVT LTD
Plot No. 36B, Sector-32, Institutional Area,
Gurgaon, Haryana, 122001, India
Tel.: 91-124-4595500
Fax: 91-124-4595550

TO BE READ WITH THIS OFFICE MEMO NO. 20/21
DATED: 20-01-2023

(Signature)
ARCHITECT
ARCOP ASSOCIATES PVT. LTD.
BPAAC, BPA, BPAAC

(Signature)
DIPAN MISHRA (ATP)
BPAAC

(Signature)
ATPHQ

(Signature)
Ravi Kumar Bhasin
JD(HQ)

(Signature)
BPAAC

(Signature)
BPAAC

(Signature)
BPAAC

(Signature)
BPAAC

(Signature)
BPAAC

2. All piping plans have been checked and found in order as per Public Health Services point of view.

(Signature)
BPAAC

(Signature)
BPAAC

(Signature)
BPAAC

(Signature)
BPAAC

(Signature)
BPAAC


(Signature)
BPAAC

DLF Home Developer Pvt. Ltd.
Authorised Signatory
ARCHITECT
BPAAC, BPAAC, BPAAC
No. CA/2003/2007
13/1/2018


JAN.-2023, Scale : N.T.S

Drawing No. :- SD-01
SCHEMATIC DIAGRAM ALL TOWER & EWS



DOMESTIC WATER SUPPLY SCHEMATIC FOR TOWER A, B, C

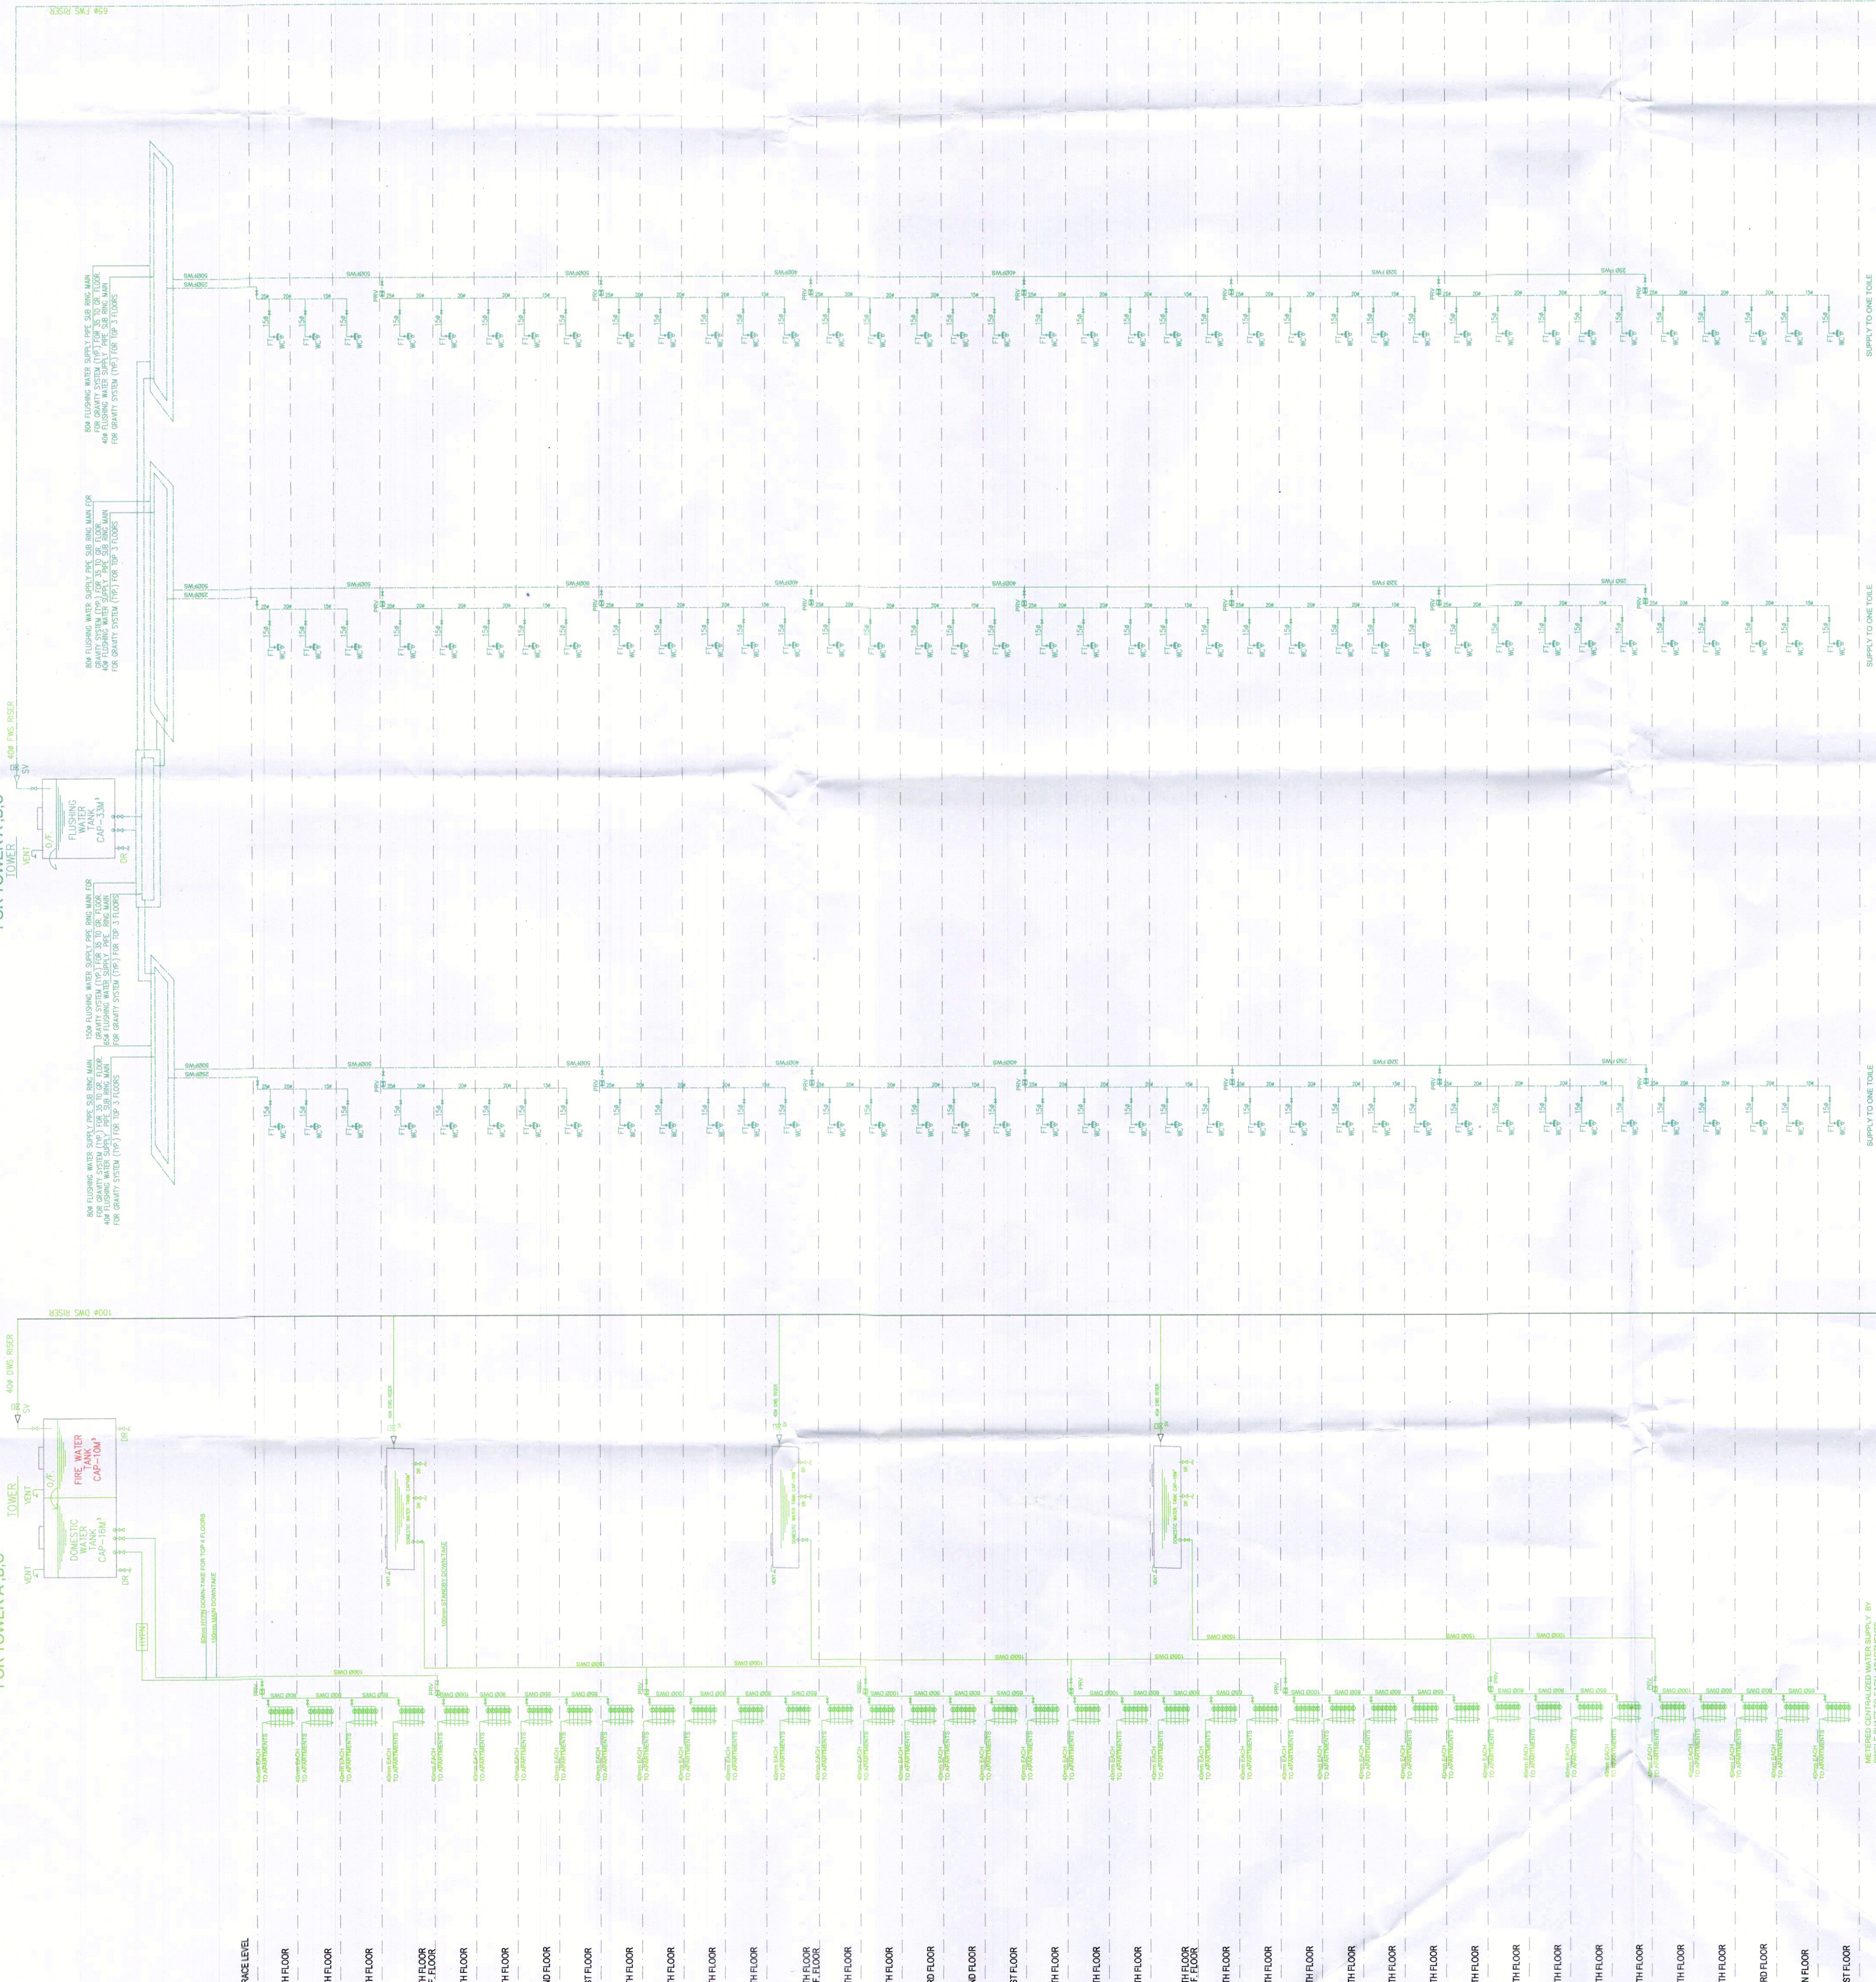

FLUSHING WATER SUPPLY SCHEMATIC FOR TOWER A, B, C

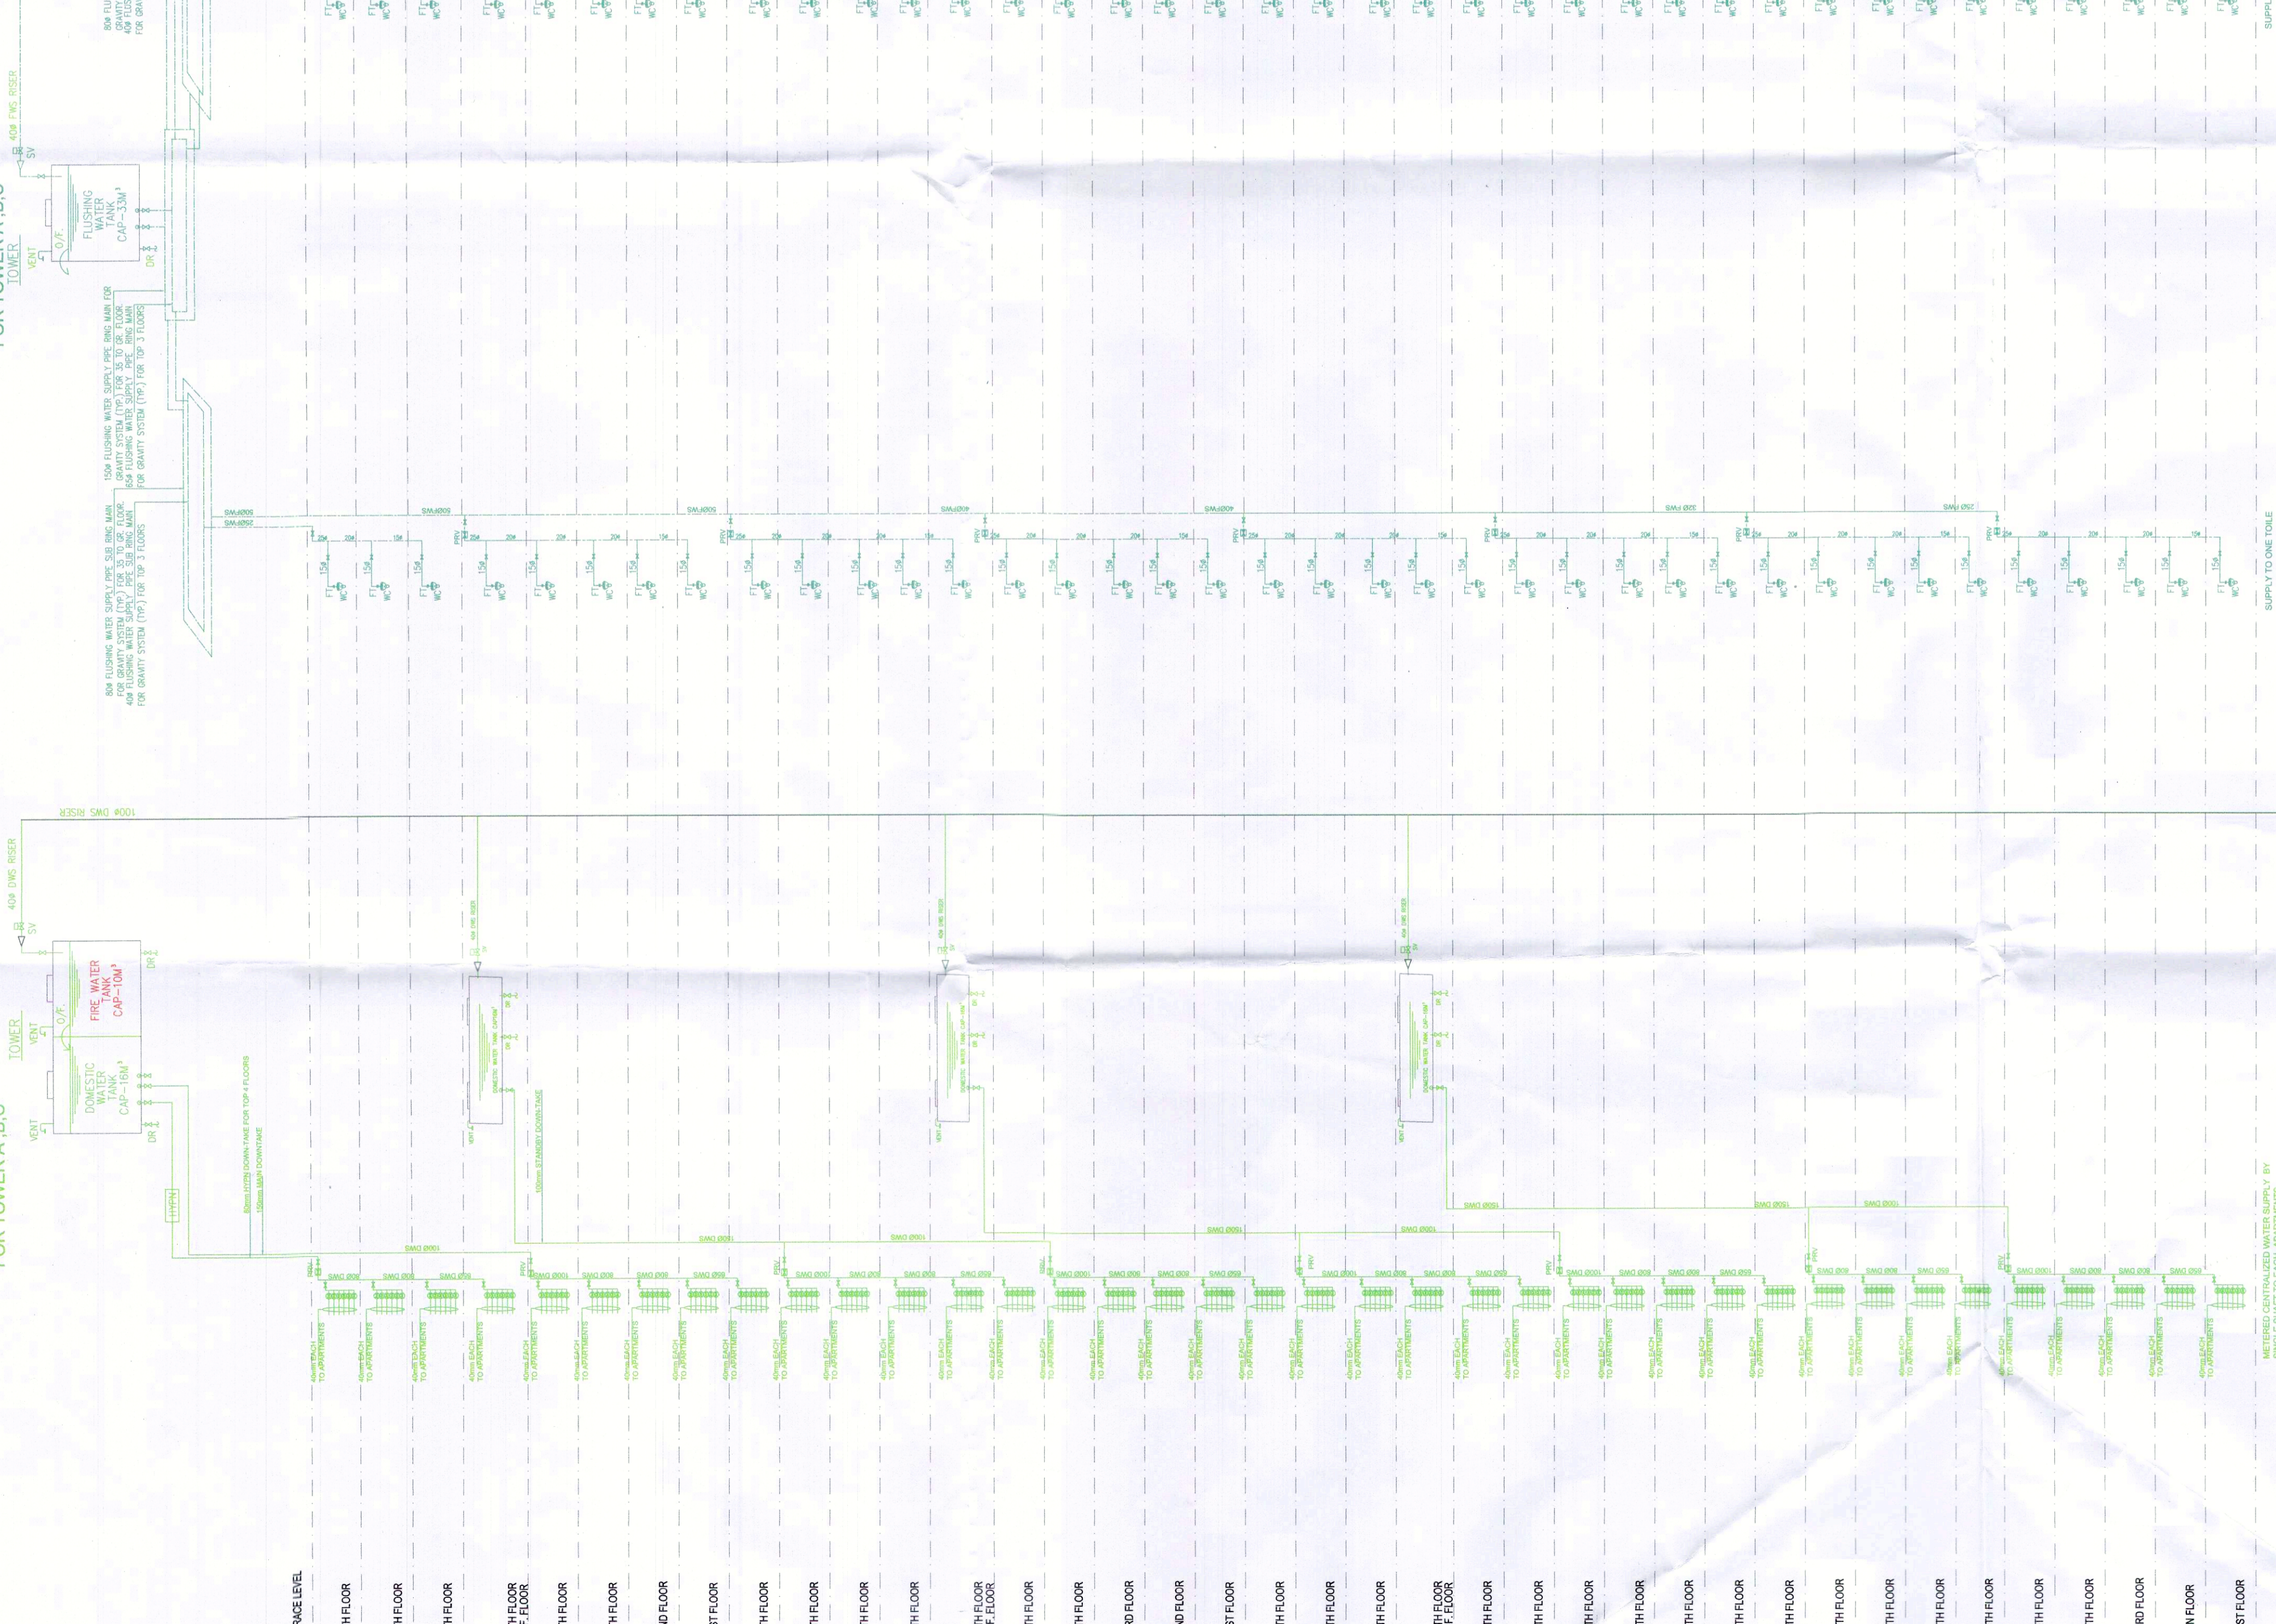

FLUSHING WATER SUPPLY SCHEMATIC FOR CONVENIENT SHOPPING

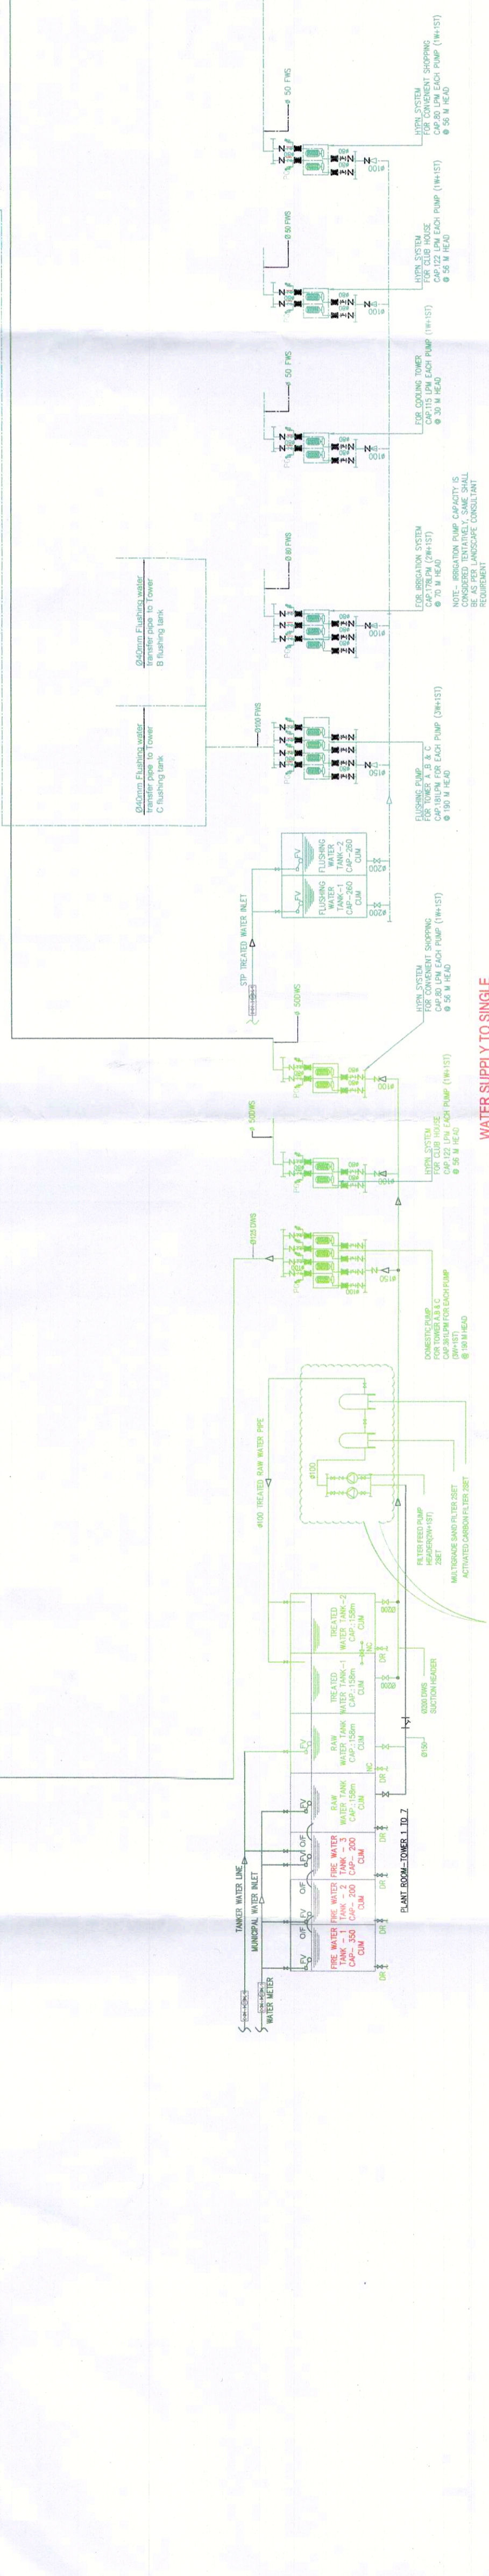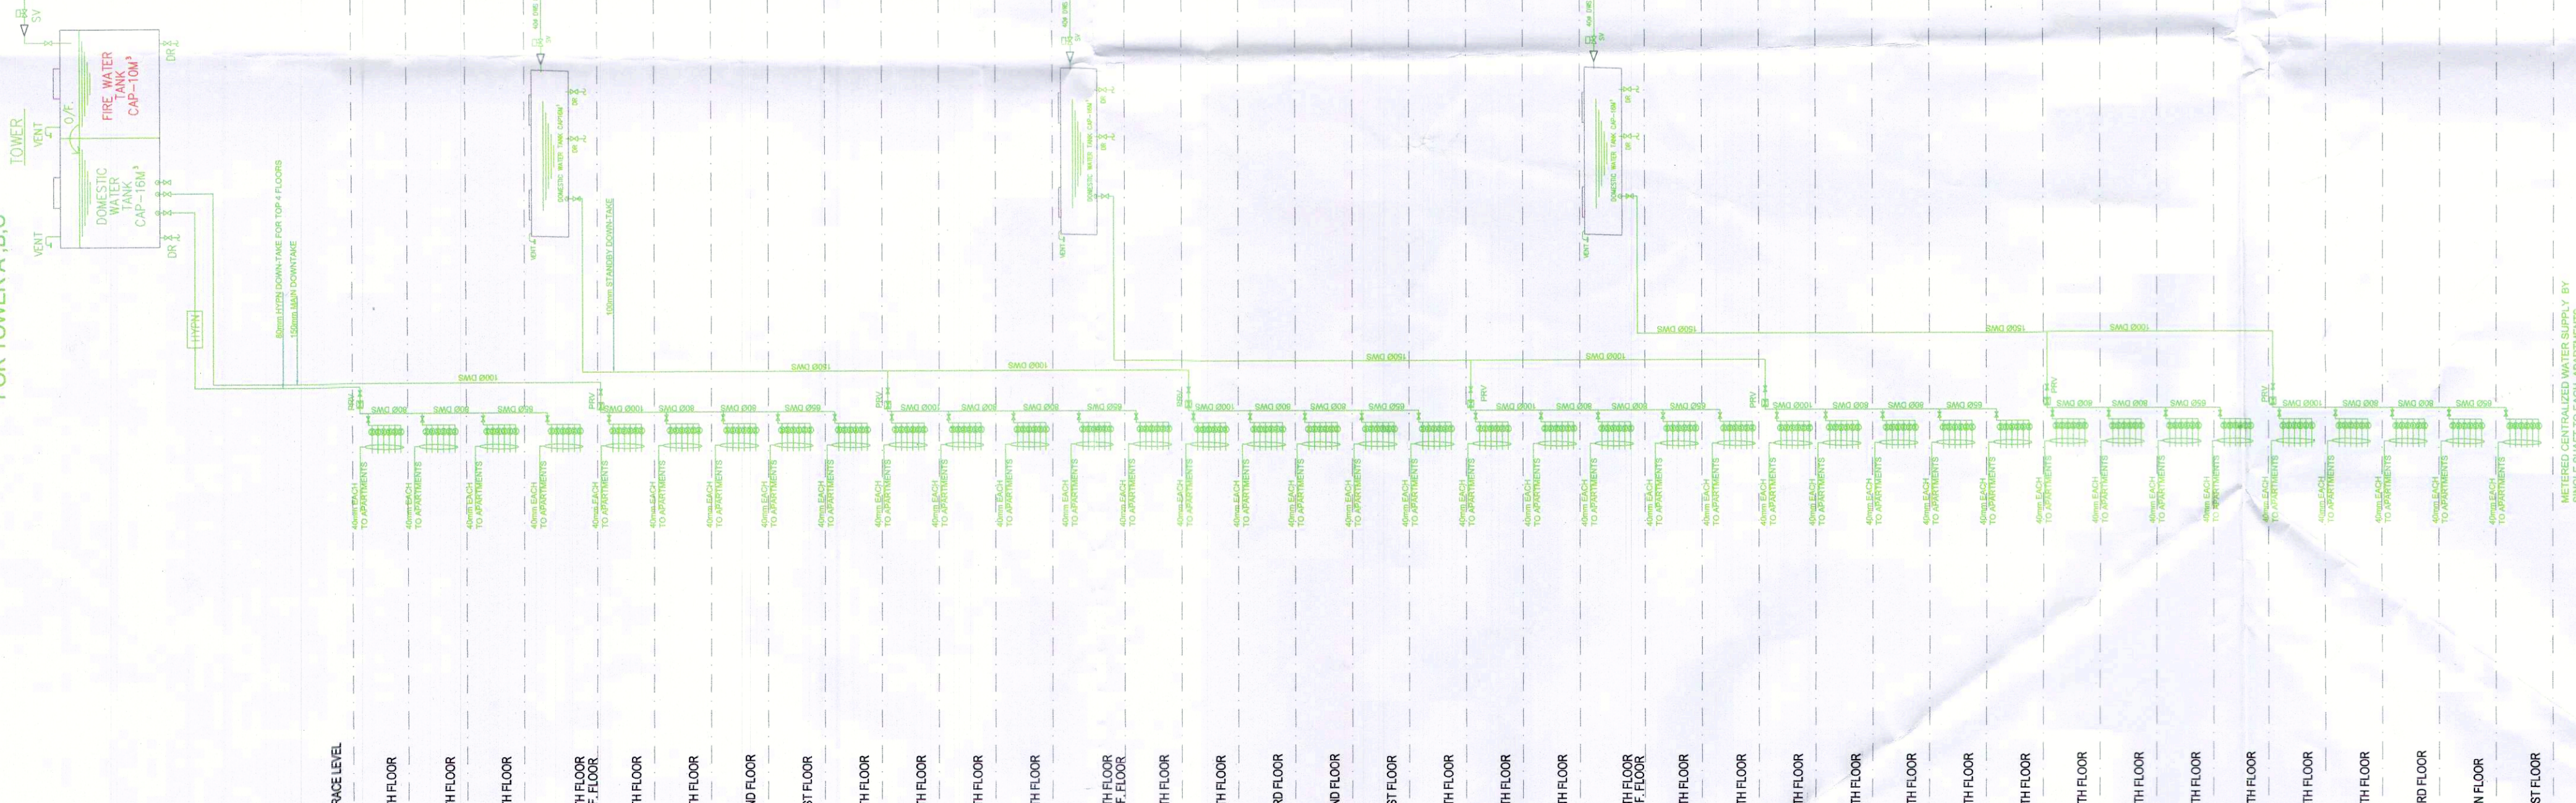

WATER SUPPLY TO SINGLE TOILET IN SINGLE SHIFT

Drawing No. :- SD-01

SCHEMATIC DIAGRAM ALL TOWER & EWS