

Note :-

1. BUILDING WILL BE DESIGNED (STRUCTURES) AS PER RELEVANT IS CODES FOR EARTH QUAKE RESISTANCE.
2. THE BUILDING IS ARTIFICIALLY LIT AND MECHANICALLY VENTILATED.

LEGEND :-

PROJECT :

REVISED BUILDING PLANS OF GROUP HOUSING COLONY AREA MEASURING 25.087 ACRES (LICENCE NO. 123 OF 2012 DATED 20-12-2012 IN SECTOR-63, GURGAON BEING DEVELOPED BY 'ARLIE BUILDERS & DEVELOPERS PVT. LTD.' AND OTHERS IN COLLABORATION WITH DLF HOME DEVELOPERS LTD (EARLIER KNOWN AS DLF NEW GURGAON HOME DEVELOPERS PVT.LTD)


ARCHITECTURE:
ARCOP

ARCOP ASSOCIATES PVT LTD
Plot No. 36B, Sector-32, Institutional Area, Gurugram, Haryana, 122001, India
Tel.: 91-124-4595500
Fax: 91-124-4595550

TO BE READ WITH THIS OFFICE
MEMO NO. 38/2013
DATED: 28-01-2013

ARCHITECT'S SEAL & SIGNATURE
OWNERS SEAL & SIGNATURE
DLF Home Developers Limited
Authorized Signatory

JAN - 2013, Scale : 1:100
Drawing Title :-
MACHINE ROOM-2 PLAN & ROOF PLAN
TOWER-D
Drawing No. :-
TD-06

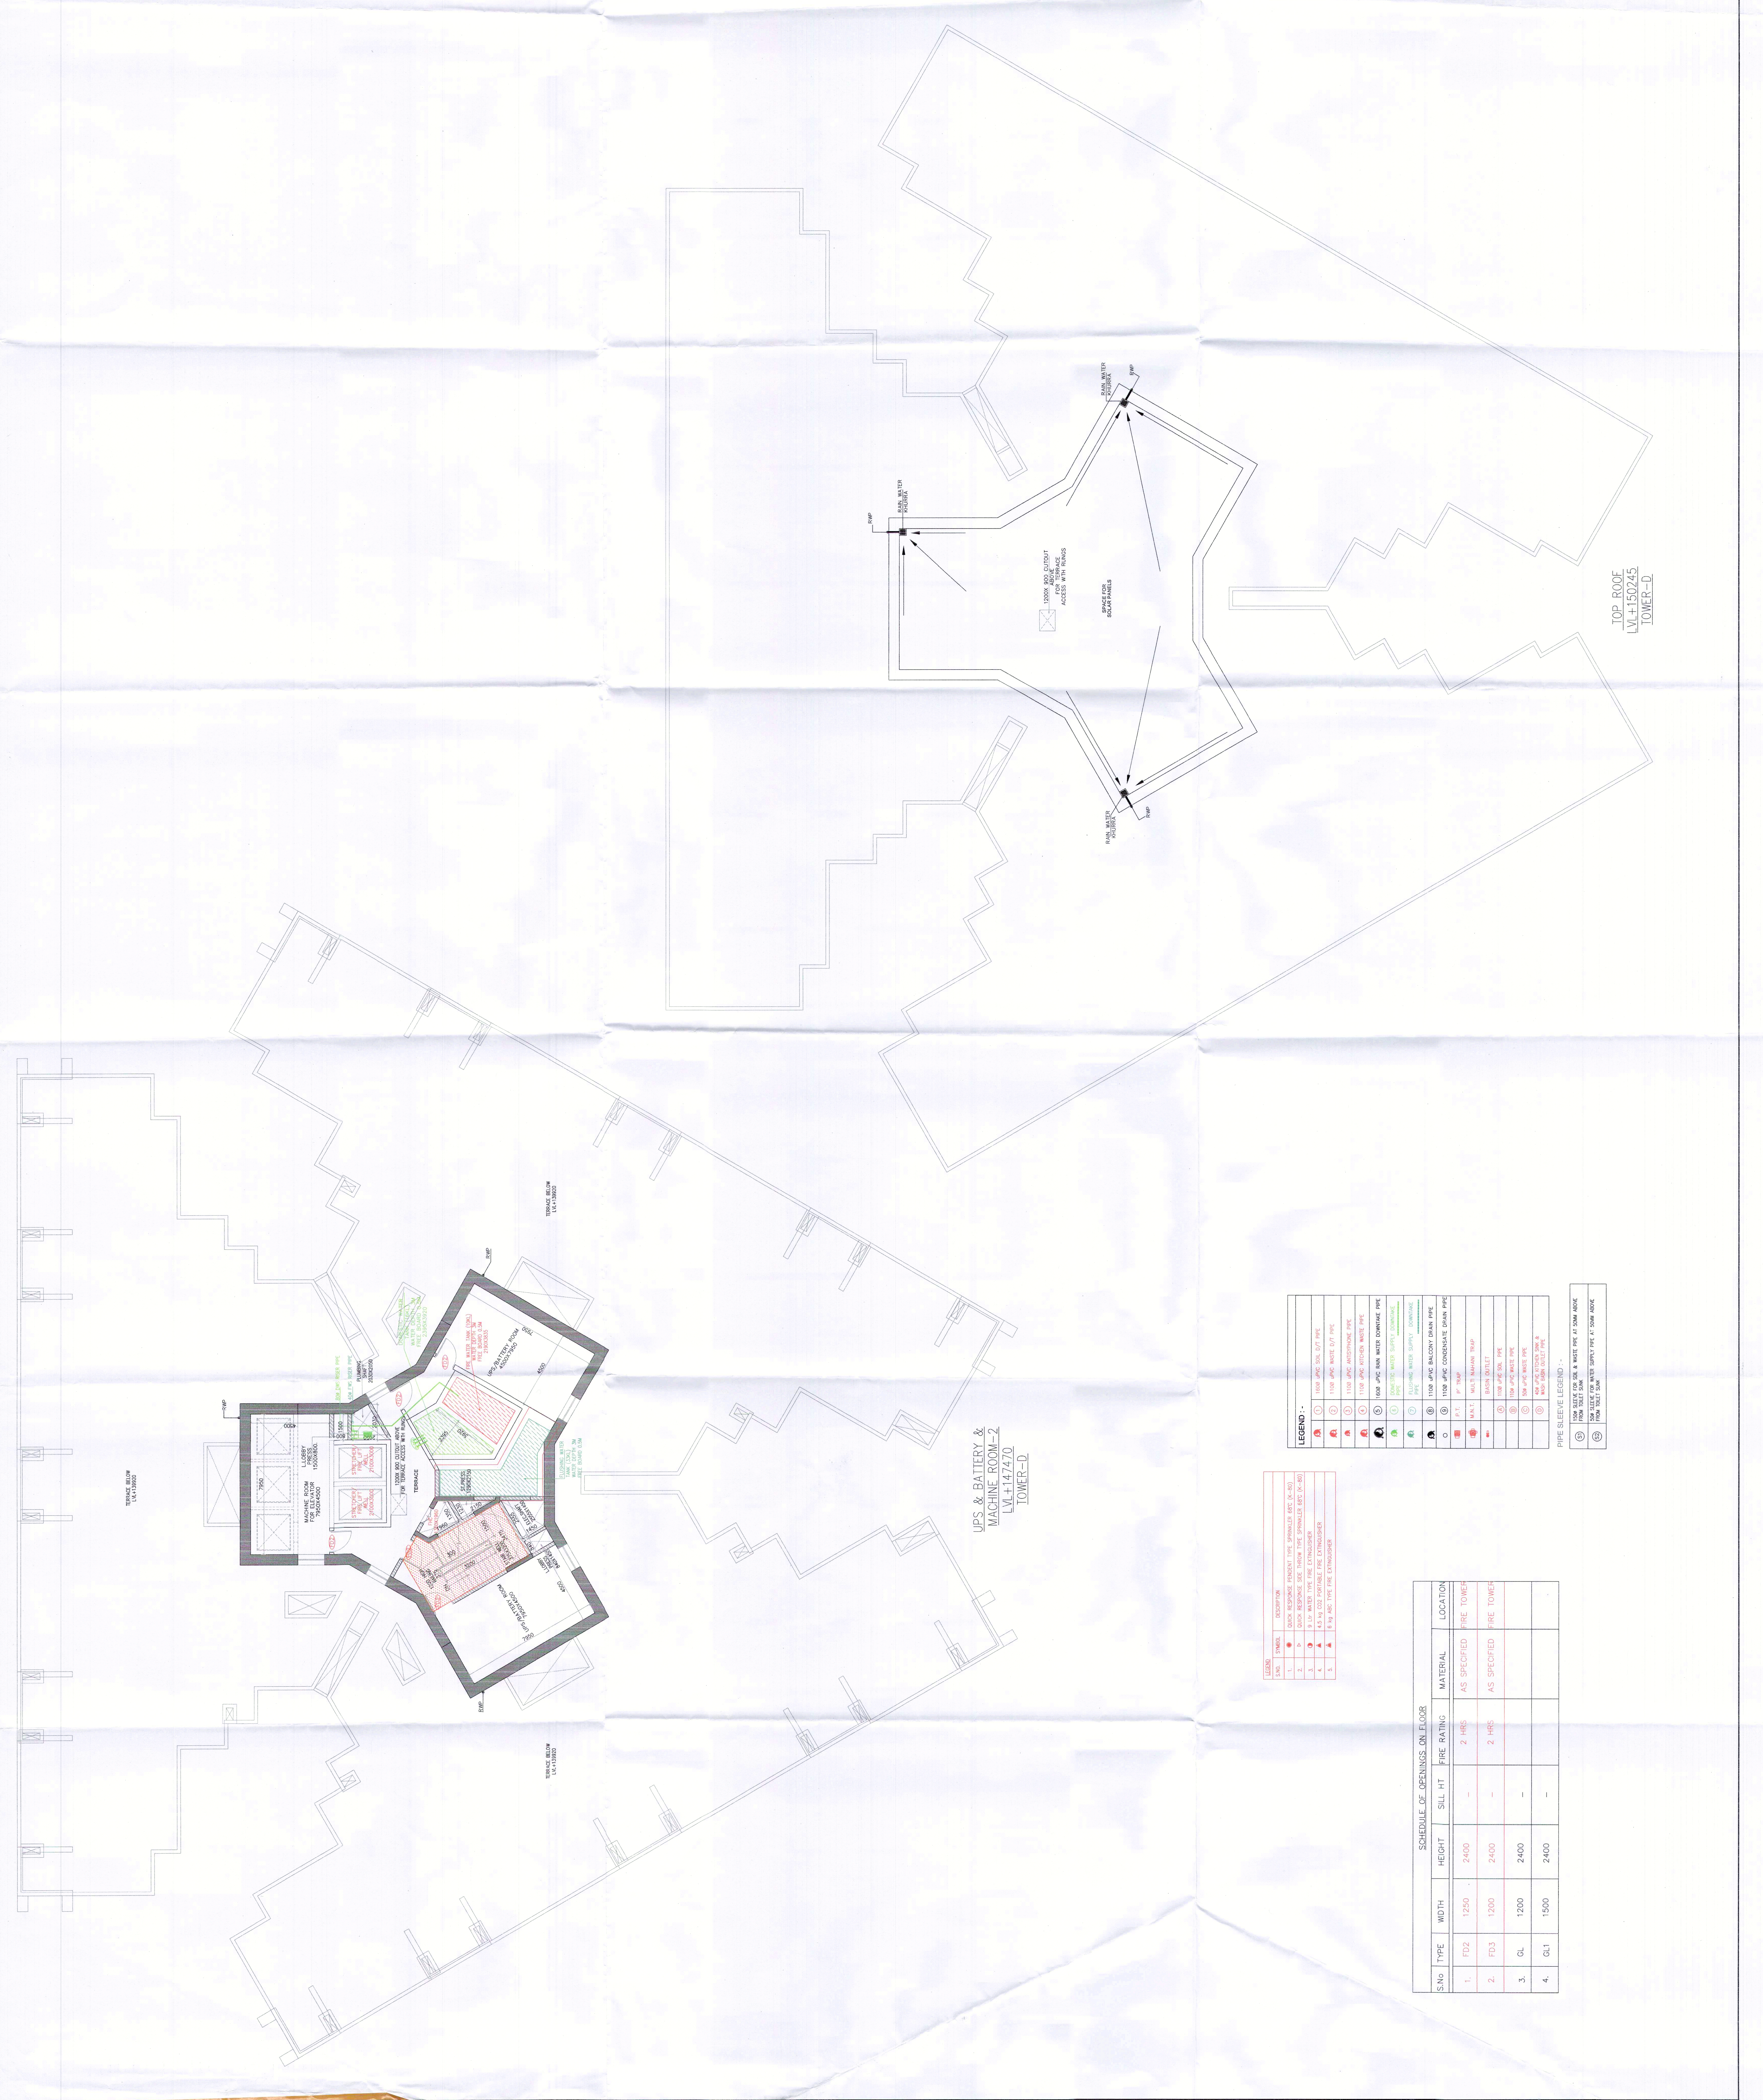

UPS & BATTERY & MACHINE ROOM-2
LV+14.74.70
TOWER-D

LEGEND :-

1	1000 JWC COIL (2) PIPE
2	1000 JWC COIL (2) PIPE
3	1000 JWC WATER (2) PIPE
4	1000 JWC AIRSTRONG PIPE
5	1000 JWC AIRSTRONG WATER PIPE
6	1000 JWC RAIN WATER DRAINAGE PIPE
7	1000 JWC RAIN WATER DRAINAGE PIPE
8	1000 JWC RAIN WATER DRAINAGE PIPE
9	1000 JWC RAIN WATER DRAINAGE PIPE
10	1000 JWC RAIN WATER DRAINAGE PIPE
11	1000 JWC RAIN WATER DRAINAGE PIPE
12	1000 JWC RAIN WATER DRAINAGE PIPE
13	1000 JWC RAIN WATER DRAINAGE PIPE
14	1000 JWC RAIN WATER DRAINAGE PIPE
15	1000 JWC RAIN WATER DRAINAGE PIPE
16	1000 JWC RAIN WATER DRAINAGE PIPE
17	1000 JWC RAIN WATER DRAINAGE PIPE
18	1000 JWC RAIN WATER DRAINAGE PIPE
19	1000 JWC RAIN WATER DRAINAGE PIPE
20	1000 JWC RAIN WATER DRAINAGE PIPE
21	1000 JWC RAIN WATER DRAINAGE PIPE
22	1000 JWC RAIN WATER DRAINAGE PIPE
23	1000 JWC RAIN WATER DRAINAGE PIPE
24	1000 JWC RAIN WATER DRAINAGE PIPE
25	1000 JWC RAIN WATER DRAINAGE PIPE
26	1000 JWC RAIN WATER DRAINAGE PIPE
27	1000 JWC RAIN WATER DRAINAGE PIPE
28	1000 JWC RAIN WATER DRAINAGE PIPE
29	1000 JWC RAIN WATER DRAINAGE PIPE
30	1000 JWC RAIN WATER DRAINAGE PIPE

SCHEDULE OF OPENINGS ON FLOOR

S.No	TYPE	WIDTH	HEIGHT	SILL HT	FIRE RATING	MATERIAL	LOCATION
1.	FD2	1250	2400	-	2 HRS	AS SPECIFIED	FIRE TOWER
2.	FD3	1200	2400	-	2 HRS	AS SPECIFIED	FIRE TOWER
3.	GL	1200	2400	-	-	-	-
4.	GL1	1500	2400	-	-	-	-

PIPE SLEEVE LEGEND :-
1. 1000 JWC RAIN WATER PIPE AT 1000mm HOOD
2. 1000 JWC RAIN WATER PIPE AT 1000mm HOOD
3. 1000 JWC RAIN WATER PIPE AT 1000mm HOOD