


**Note :-**

- BUILDING HAS AUTOMATIC SPRINKLER SYSTEM.
- BUILDING WILL BE DESIGNED (STRUCTURES) AS PER RELEVANT IS CODES FOR EARTH QUAKE RESISTANCE.
- BUILDING IS ARTIFICIALLY LIGHTED MECHANICALLY VENTILATED AND AIR CONDITIONED WITH 100% POWER BACKUP.
- ALL THE SHAFT WILL BE PROVIDED WITH GALVANIZED METAL GRATING FLUSH TO THE ROAD LEVEL TO TAKE FIRE TENDER LOAD.

**PROJECT:**  
 PROPOSED BUILDING PLAN OF (SUMMIT PLAZA)  
 COMMERCIAL SITE UNDER TRANSIT ORIENTED DEVELOPMENT (TOD) POLICY DATED 09.02.2016 ON THE AREA MEASURING 2.65 ACRES FALLING IN RESIDENTIAL CUM-GROUP HOUSING COLONY NAMED DLF-5 FORMERLY KNOWN AS DLF CITY PHASE-V, GURUGRAM BEING DEVELOPED BY DLF LIMITED.

**ASSOCIATE ARCHITECTS**  
**RISIMIS ARCHITECTS**  
 RIMS ARCHITECTS PVT. LTD.  
 69, Nara Nivas Bhawan, Kunj (Behind D2), Vasant Kunj, New Delhi-110070.  
 Tel: 011-26998616, 26998617  
 WWW.RISIMIS-ARCH.COM

Architects' Seal & Signature  
 Owners' Seal & Signature  
 Scale: 1:100  
 Drawing Title: 1ST FLOOR PLAN  
 Drawing No: R-02

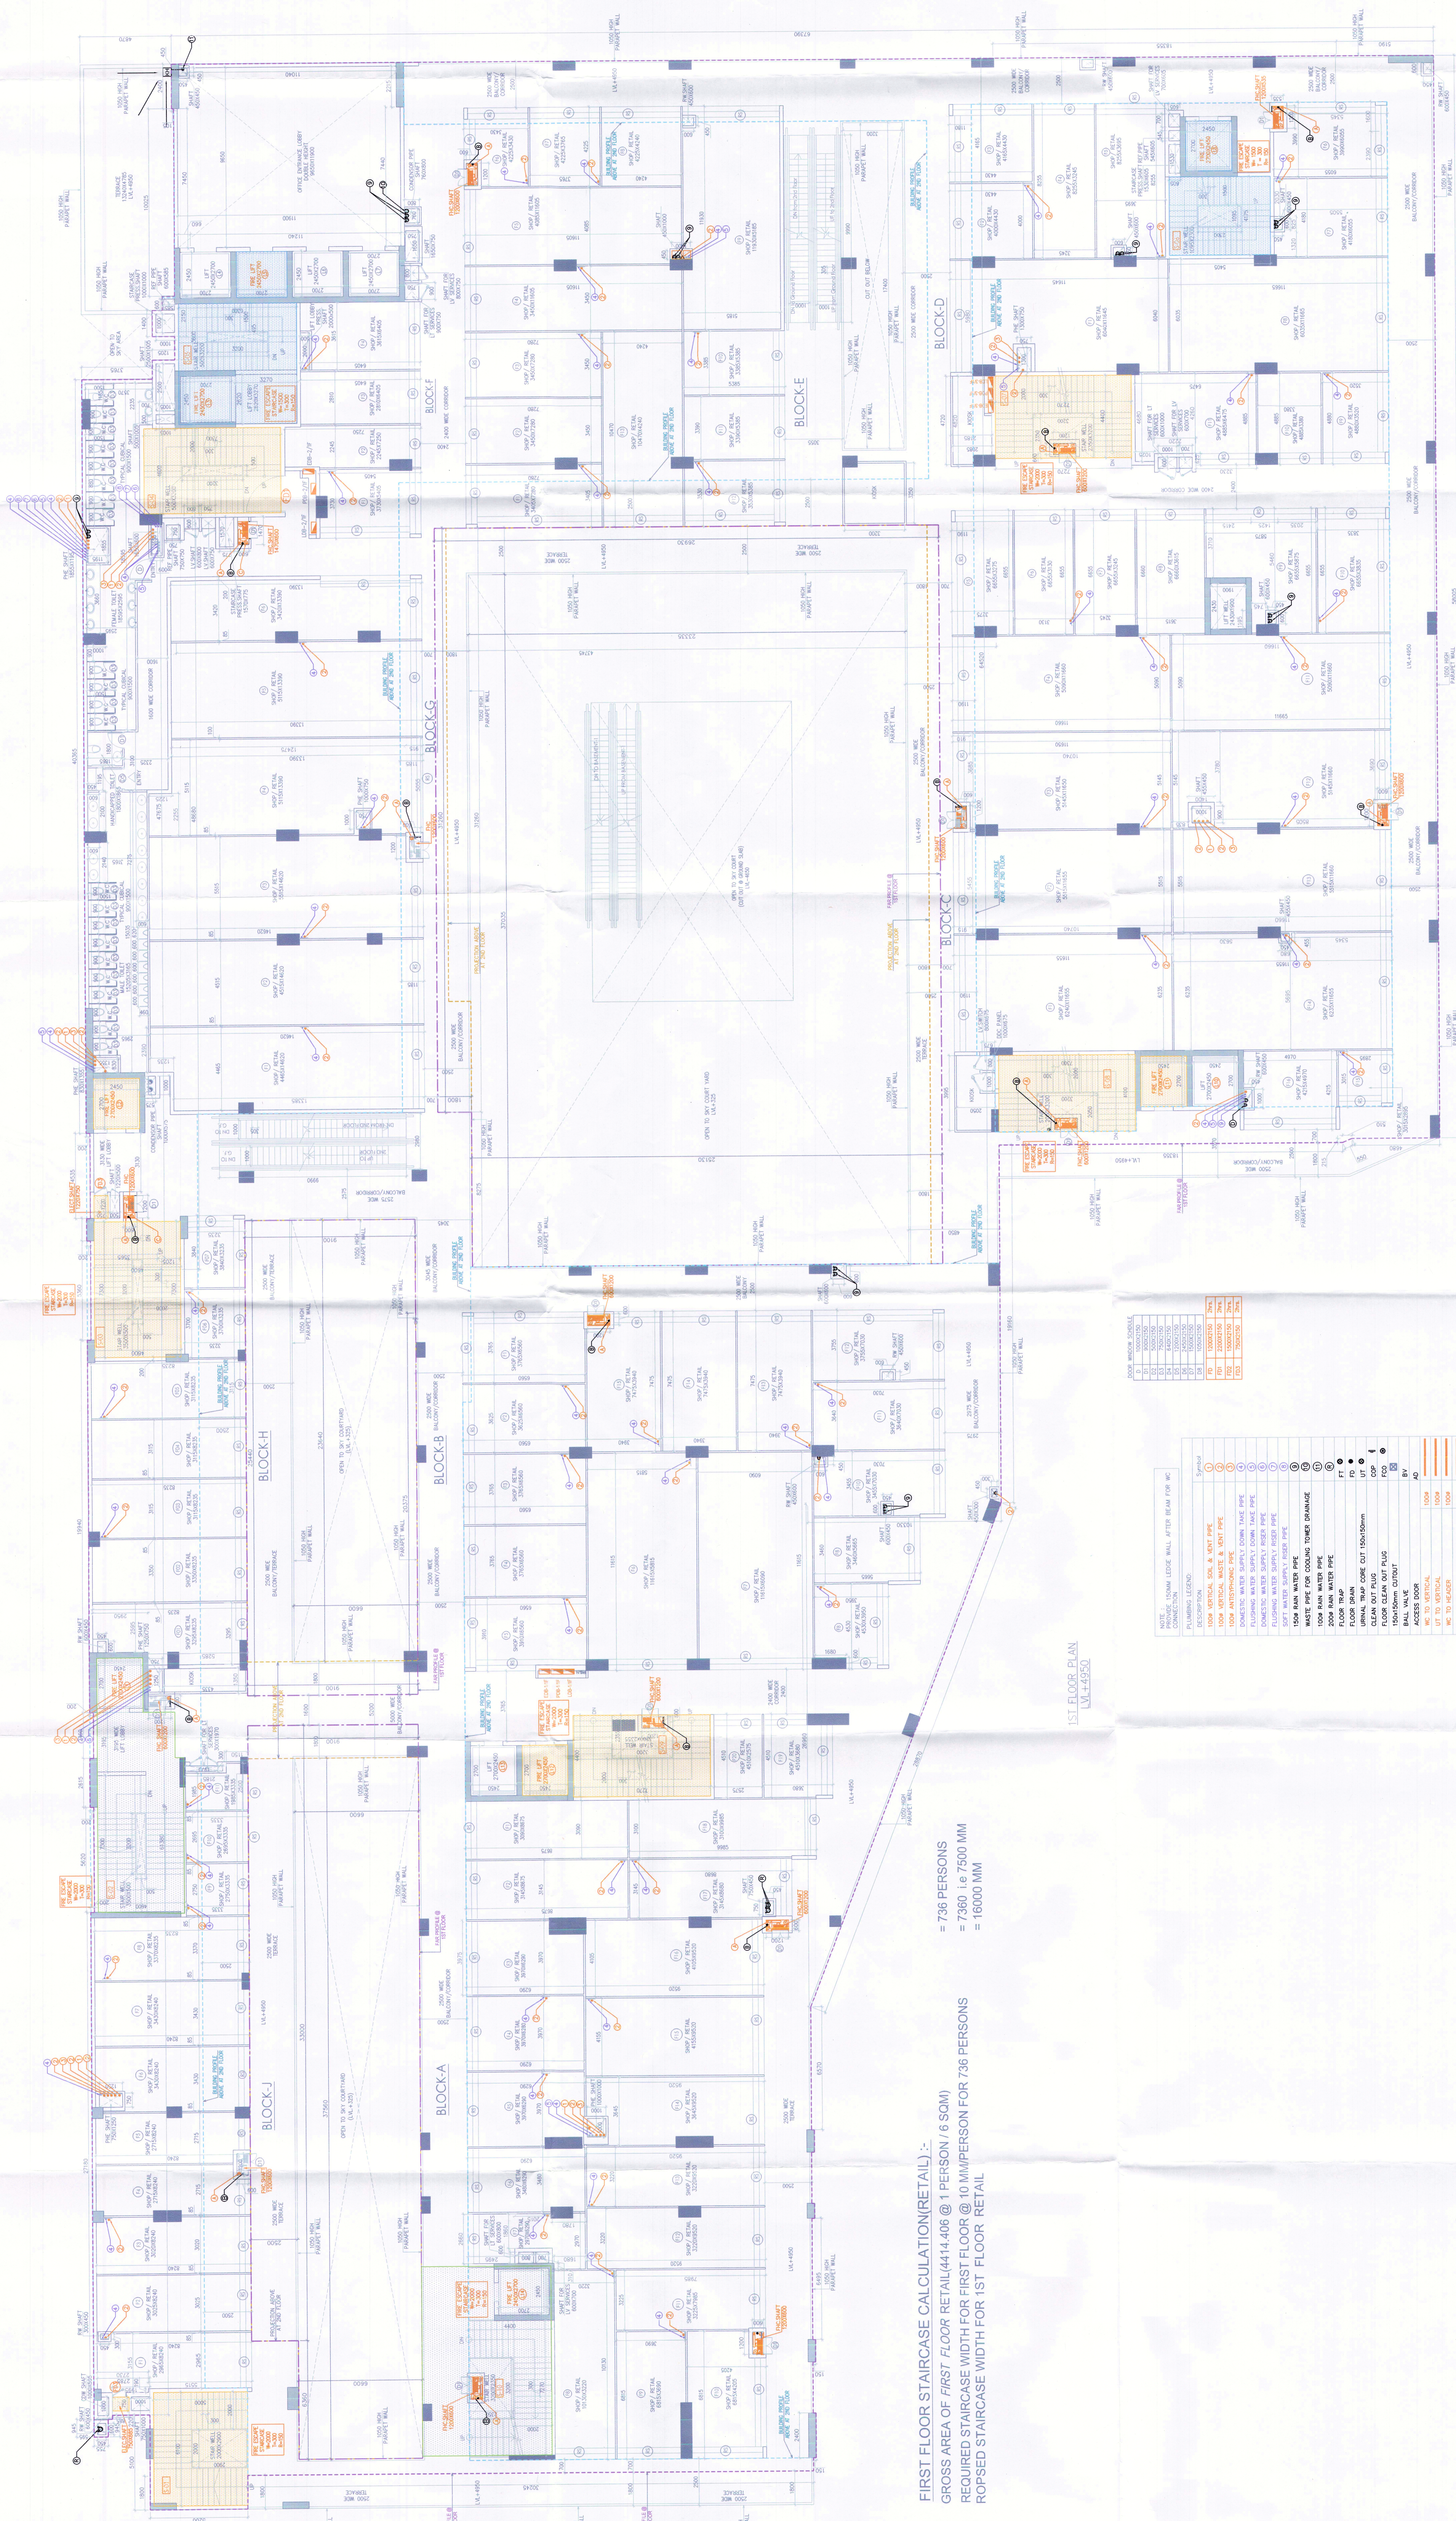

**PLUMBING LEGEND:**

SYMBOL	DESCRIPTION
1	100M VERTICAL WATER INLET PIPE
2	100M VERTICAL WATER & WWT PIPE
3	100M ANTI-SIPHON PIPE
4	DOMESTIC WATER SUPPLY DOWN TAKE PIPE
5	DOMESTIC WATER SUPPLY RISER PIPE
6	PLUMBING WATER SUPPLY RISER PIPE
7	COFF WATER SUPPLY RISER PIPE
8	WASTE PIPE FOR COOKING TOPS DRAINAGE
9	100M RAIN WATER PIPE
10	100M RAIN WATER PIPE
11	100M RAIN WATER PIPE
100	100M RAIN WATER PIPE

**NOTE:**

- ALL INTERNAL WALL ARE 70 TO 85 MM THICK PARTITION WALL.
- ALL EXTERNAL WALL ARE 200 MM BLOCK WORK AND FRONT WALL ARE ROLLING SHUTTER.
- DIMENSION OF THE AREA WHICH HAS BEEN DEDUCTED FROM THE CARPET AREA HAS BEEN SHOWN.
- ROLLING SHUTTER HAS BEEN GIVEN FOR SHOP FRONTAGE HAS BEEN INDICATED AS (RS).

**FIRST FLOOR STAIRCASE CALCULATION (RETAIL) :-**  
 GROSS AREA OF FIRST FLOOR RETAIL (414.406 @ 1 PERSON / 6 SQM)  
 REQUIRED STAIRCASE WIDTH FOR FIRST FLOOR @ 10 MM/PERSON FOR 736 PERSONS  
 = 7360 i.e 7500 MM  
 ROPSED STAIRCASE WIDTH FOR 1ST FLOOR RETAIL  
 = 16000 MM

1ST FLOOR PLAN  
 L.M.-4950