

- BUILDING HAS AUTOMATIC SPRINKLER SYSTEM.
- BUILDING WILL BE DESIGNED (STRUCTURES) AS PER RELEVANT IS CODES FOR EARTH QUAKE RESISTANCE.
- BUILDING IS ARTIFICIALLY LIGHTED MECHANICALLY VENTILATED AND AIR CONDITIONED WITH 100% POWER BACKUP.
- ALL THE SHAFT WILL BE PROVIDED WITH GALVANIZED METAL GRATING FLUSH TO THE ROAD LEVEL TO TAKE FIRE TENDER LOAD.


PROJECT:
 PROPOSED BUILDING PLAN OF (SUMMIT PLAZA) COMMERCIAL SITE UNDER TRANSIT ORIENTED DEVELOPMENT (TOD) POLICY DATED 08.02.2016 ON THE AREA MEASURING 2.85 ACRES FALLING IN RESIDENTIAL CUM-GROUP HOUSING COLONY NAMED DLF-5 FORMERLY KNOWN AS DLF CITY PHASE-V, GURGRAM BEING DEVELOPED BY DLF LIMITED.
ASSOCIATE ARCHITECTS
RISIMIS ARCHITECTS
 RMS ARCHITECTS PVT. LTD.
 65 Nara Niwas (Bhawani Kunj), (Behind D2), Vasant Kunj, New Delhi-110070.
 Tel: 011-26898616, 26898617
 www.rsms-arch.com

13 APRIL - 2021 | Scale : 1:100 | Drawing No: R-05

ARCHITECTS SEAL & SIGNATURE

OWNER'S SEAL & SIGNATURE

4TH FLOOR PLAN

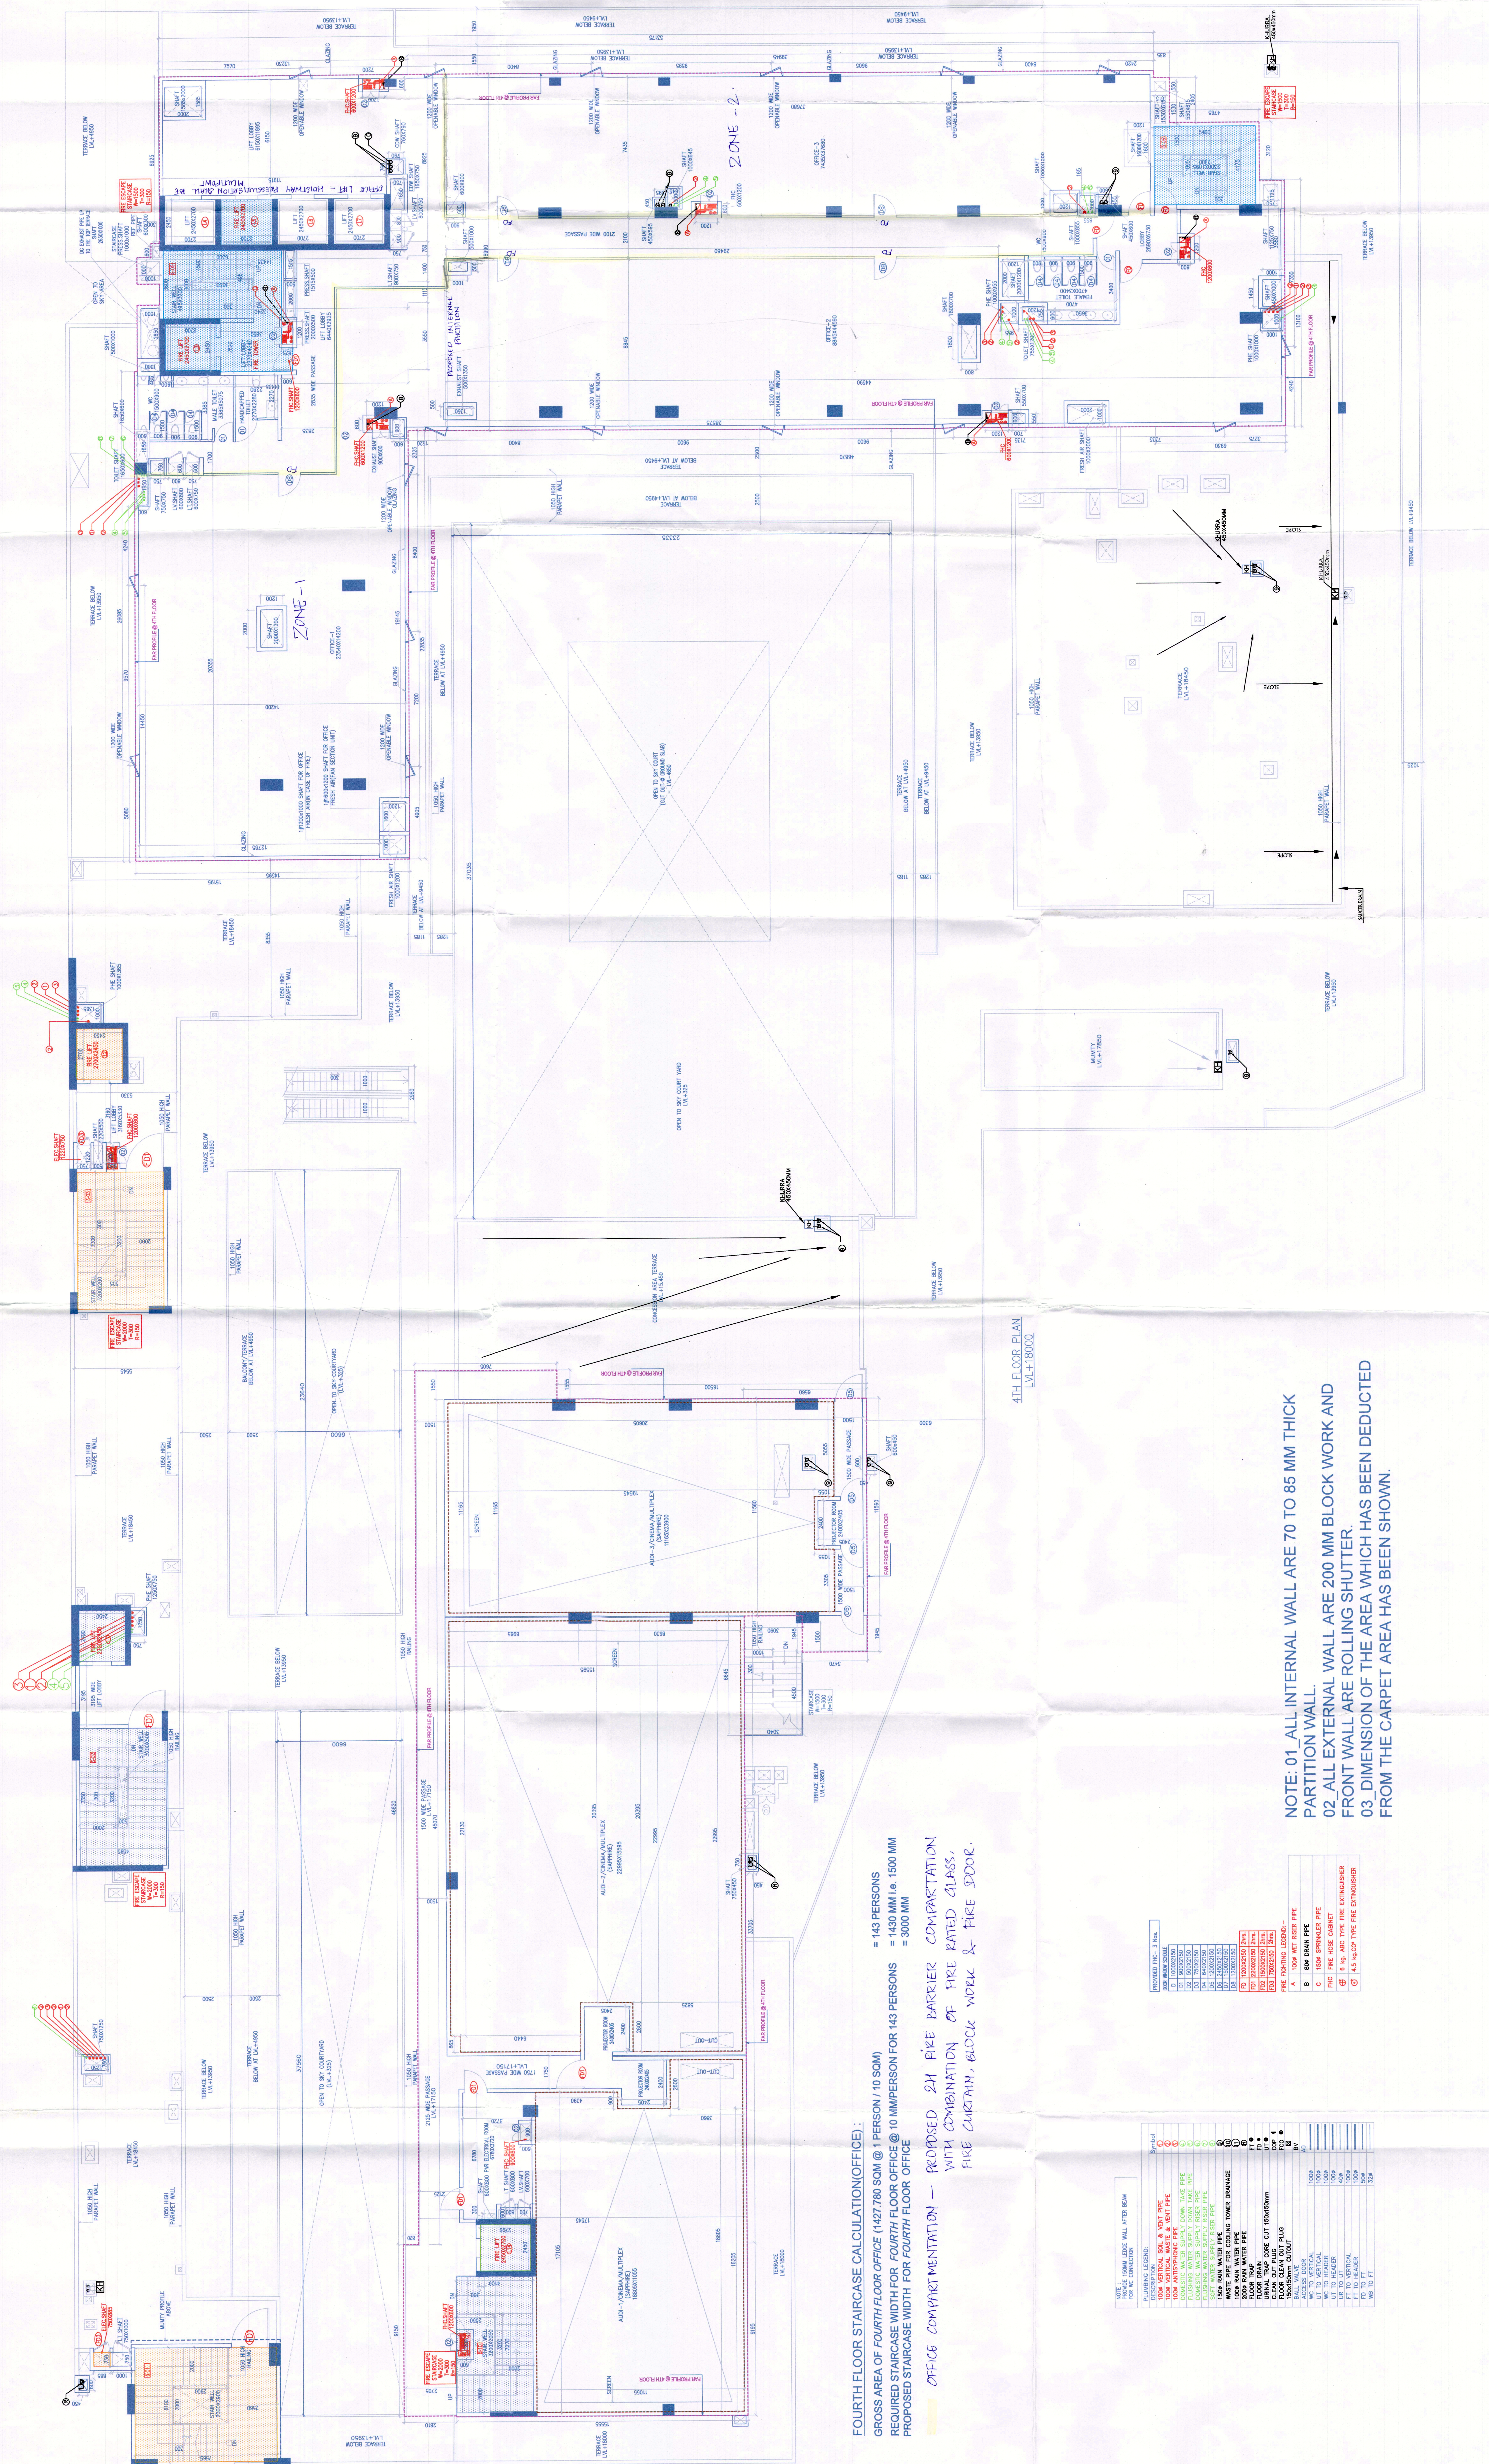

FOURTH FLOOR STAIRCASE CALCULATION(OFFICE):
 GROSS AREA OF FOURTH FLOOR OFFICE (1427.780 SQM @ 1 PERSON / 10 SQM)
 REQUIRED STAIRCASE WIDTH FOR FOURTH FLOOR OFFICE @ 10 MPERSON FOR 143 PERSONS = 1430 MM i.e. 1500 MM
 PROPOSED STAIRCASE WIDTH FOR FOURTH FLOOR OFFICE = 4000 MM

OFFICE COMPARTMENTATION — PROPOSED 2H FIRE BARRIER COMPARTMENTATION WITH COMBINATION OF FIRE RATED GLASS, FIRE CURTAIN, BLOCK WORK & FIRE DOOR.

SYMBOL	DESCRIPTION	QUANTITY
1	100MM METRICK FIRE	1
2	100MM METRICK FIRE	1
3	100MM METRICK FIRE	1
100	100MM METRICK FIRE	1

NOTE:
 01. ALL INTERNAL WALL ARE 70 TO 85 MM THICK PARTITION WALL.
 02. ALL EXTERNAL WALL ARE 200 MM BLOCK WORK AND FRONT WALL ARE ROLLING SHUTTER.
 03. DIMENSION OF THE AREA WHICH HAS BEEN DEDUCTED FROM THE CARPET AREA HAS BEEN SHOWN.