

1. BUILDING WILL BE DESIGNED (STRUCTURES) AS PER RELEVANT IS CODES FOR EARTH QUAKE RESISTANCE.
2. THE BUILDING IS ARTIFICIALLY LIT AND MECHANICALLY VENTILATED.

SCHEDULE OF CEILING/ON FLOOR

SNO	TYPE	WIDTH	HEIGHT	SKILL HT	FIRE FLOOR	FIRE RATING	MATERIAL	LOCATION
1.	FD	1500	2400	-	-	3 HRS	AS SPECIFIED	FIRE TOWER
2.	FD	1500	2400	-	-	3 HRS	AS SPECIFIED	FIRE TOWER
3.	DL	1500	2400	-	-	-	-	-
4.	DL	1500	2400	-	-	-	-	-

PROJECT :

REVISED BUILDING PLANS OF GROUP HOUSING COLONY AREA MEASURING 25.087 ACRES (LICENCE NO. 123 OF 2012 DATED 20-12-2012 IN SECTOR-63, GURGAON BEING DEVELOPED BY ARLIE BUILDERS & DEVELOPERS PVT. LTD. AND OTHERS IN COLLABORATION WITH DLF HOME DEVELOPERS LTD (EARLIER KNOWN AS DLF NEW GURGAON HOME DEVELOPERS PVT.LTD)

ARCHITECTURE:
ARCOP

ARCOP ASSOCIATES PVT LTD
Plot No. 36B, Sector-32, Institutional Area, Gurugram, Haryana, 122001, India
Tel.: 91-124-4595500
91-124-4595550
Fax: 91-124-4595550


TO BE READ WITH THE OFFICE MEMO DATED: 20-01-2023

APRO SVP (HO) [Signature]
SVP (HO) [Signature]
SVP (HO) [Signature]
SVP (HO) [Signature]

ARCHITECT'S SEAL & SIGNATURE [Signature]
OWNER'S SEAL & SIGNATURE [Signature]
DLF Home Developers Limited
PRATEEK BHATTAGAR
DIPLOMA IN ARCHITECTURE
Registration No. CA10010077

JAN.-2023. Scale : 1:100
Drawing Title - MACHINE ROOM-2 PLAN & ROOF PLAN TOWER-B
Drawing No. - TB-06

Building plans have been checked and found to conform as per Public Health Statutes past & in force.

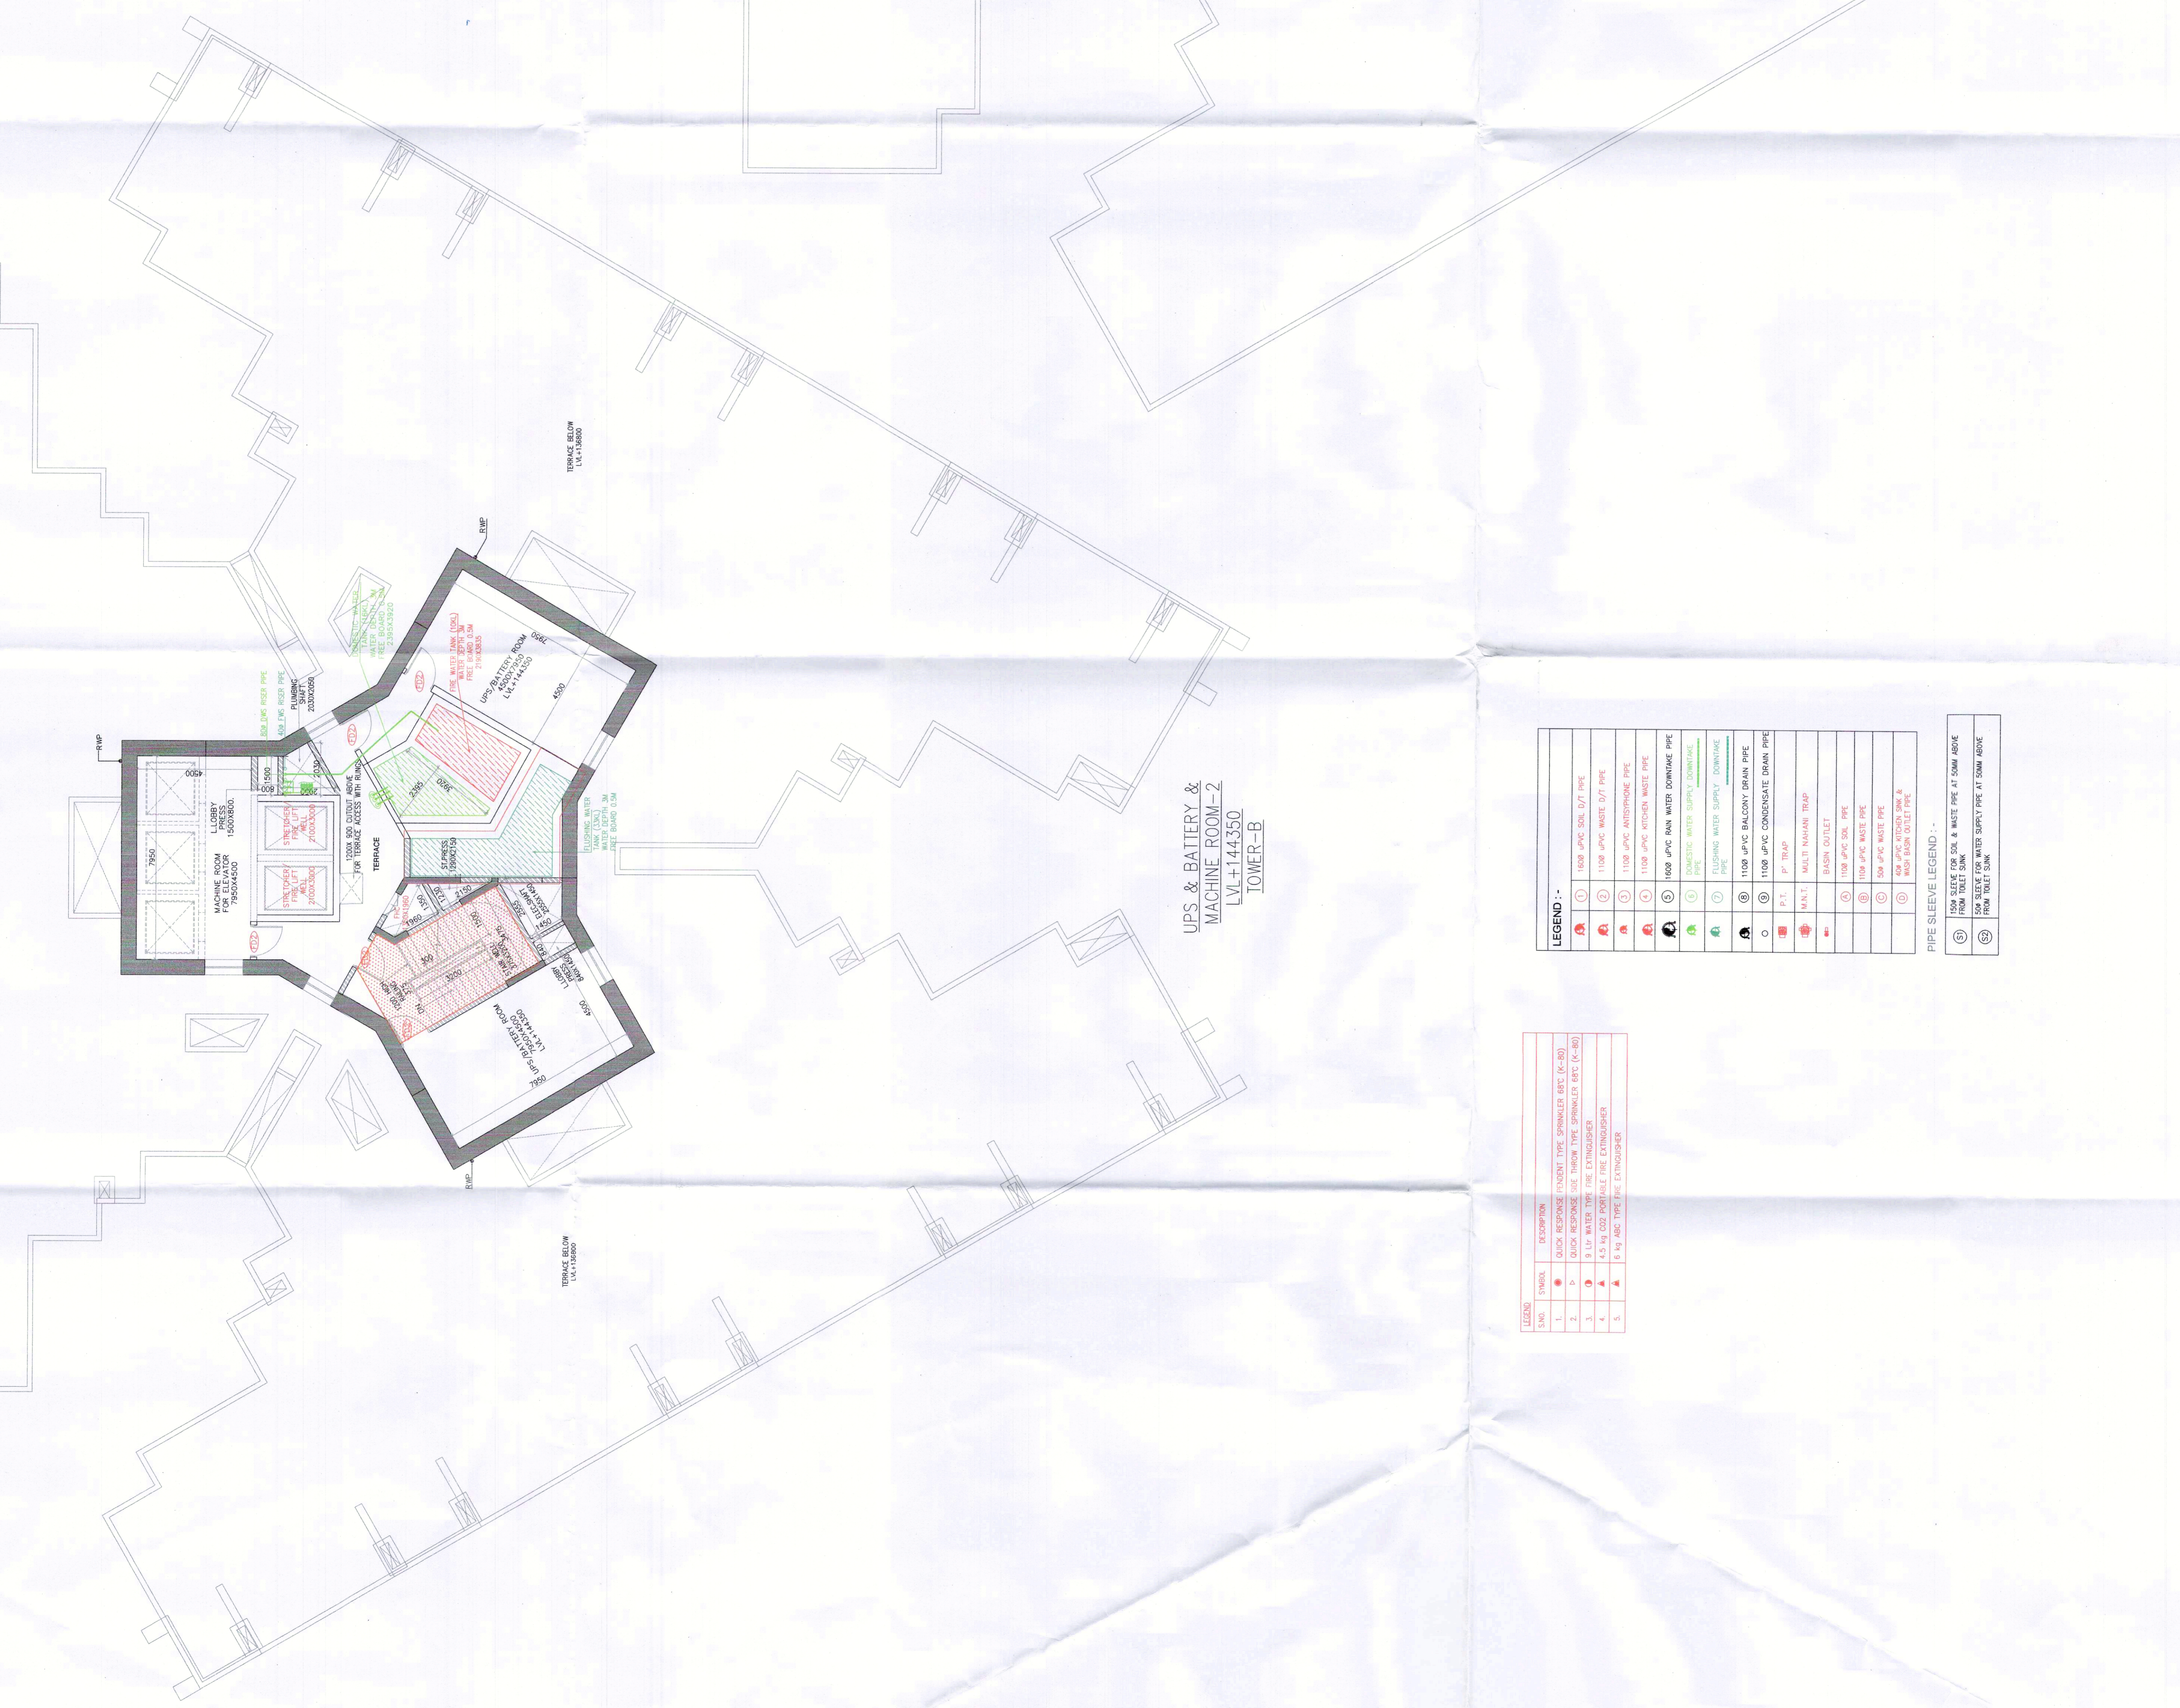

LEGEND

NO.	SYMBOL	DESCRIPTION
1.	(Symbol)	2.000 RESPONSE (SMALL TYPE SPRINKLER) (S-20)
2.	(Symbol)	2.000 RESPONSE (LARGE TYPE SPRINKLER) (S-20)
3.	(Symbol)	2.000 RESPONSE (LARGE TYPE SPRINKLER) (S-20)
4.	(Symbol)	2.000 RESPONSE (LARGE TYPE SPRINKLER) (S-20)
5.	(Symbol)	2.000 RESPONSE (LARGE TYPE SPRINKLER) (S-20)

PIPE SLEEVE LEGEND

NO.	SYMBOL	DESCRIPTION
1.	(Symbol)	1000 APFC DRAIN PIPE
2.	(Symbol)	1000 APFC WATER SUPPLY PIPE
3.	(Symbol)	1000 APFC WASTE WATER PIPE
4.	(Symbol)	1000 APFC WASTE WATER PIPE
5.	(Symbol)	1000 APFC WASTE WATER PIPE
6.	(Symbol)	1000 APFC WASTE WATER PIPE
7.	(Symbol)	1000 APFC WASTE WATER PIPE
8.	(Symbol)	1000 APFC WASTE WATER PIPE
9.	(Symbol)	1000 APFC WASTE WATER PIPE
10.	(Symbol)	1000 APFC WASTE WATER PIPE
11.	(Symbol)	1000 APFC WASTE WATER PIPE
12.	(Symbol)	1000 APFC WASTE WATER PIPE
13.	(Symbol)	1000 APFC WASTE WATER PIPE
14.	(Symbol)	1000 APFC WASTE WATER PIPE
15.	(Symbol)	1000 APFC WASTE WATER PIPE
16.	(Symbol)	1000 APFC WASTE WATER PIPE
17.	(Symbol)	1000 APFC WASTE WATER PIPE
18.	(Symbol)	1000 APFC WASTE WATER PIPE
19.	(Symbol)	1000 APFC WASTE WATER PIPE
20.	(Symbol)	1000 APFC WASTE WATER PIPE
21.	(Symbol)	1000 APFC WASTE WATER PIPE
22.	(Symbol)	1000 APFC WASTE WATER PIPE
23.	(Symbol)	1000 APFC WASTE WATER PIPE
24.	(Symbol)	1000 APFC WASTE WATER PIPE
25.	(Symbol)	1000 APFC WASTE WATER PIPE
26.	(Symbol)	1000 APFC WASTE WATER PIPE
27.	(Symbol)	1000 APFC WASTE WATER PIPE
28.	(Symbol)	1000 APFC WASTE WATER PIPE
29.	(Symbol)	1000 APFC WASTE WATER PIPE
30.	(Symbol)	1000 APFC WASTE WATER PIPE
31.	(Symbol)	1000 APFC WASTE WATER PIPE
32.	(Symbol)	1000 APFC WASTE WATER PIPE
33.	(Symbol)	1000 APFC WASTE WATER PIPE
34.	(Symbol)	1000 APFC WASTE WATER PIPE
35.	(Symbol)	1000 APFC WASTE WATER PIPE
36.	(Symbol)	1000 APFC WASTE WATER PIPE
37.	(Symbol)	1000 APFC WASTE WATER PIPE
38.	(Symbol)	1000 APFC WASTE WATER PIPE
39.	(Symbol)	1000 APFC WASTE WATER PIPE
40.	(Symbol)	1000 APFC WASTE WATER PIPE
41.	(Symbol)	1000 APFC WASTE WATER PIPE
42.	(Symbol)	1000 APFC WASTE WATER PIPE
43.	(Symbol)	1000 APFC WASTE WATER PIPE
44.	(Symbol)	1000 APFC WASTE WATER PIPE
45.	(Symbol)	1000 APFC WASTE WATER PIPE
46.	(Symbol)	1000 APFC WASTE WATER PIPE
47.	(Symbol)	1000 APFC WASTE WATER PIPE
48.	(Symbol)	1000 APFC WASTE WATER PIPE
49.	(Symbol)	1000 APFC WASTE WATER PIPE
50.	(Symbol)	1000 APFC WASTE WATER PIPE