

Note :-

- BUILDING HAS AUTOMATIC SPRINKLER SYSTEM WHEREVER REQUIRED BY NBC.
- BUILDING WILL BE DESIGNED (STRUCTURES) AS PER RELEVANT IS CODES FOR EARTH QUAKE RESISTANCE.
- BUILDING IS ARTIFICIALLY LIGHTED MECHANICALLY VENTILATED / AIRCONDITIONED & 100% POWER BACKUP.

LEGEND:-



PROJECT:
 REVISED BUILDING PLAN (REVISION 1) OF SUMMIT PLAZA DEVELOPMENT (TOD) POLICY DATED 06/02/2018 ON THE AREA MEASURING 2.65 ACRES FALLING IN RESIDENTIAL CLM GROUP HOUSING COLONY NAMED DLF-5 (FORMERLY KNOWN AS DLF CITY PHASE-V), GURUGRAM BEING DEVELOPED BY DLF LIMITED.

DESIGN ARCHITECTS
ARCOP
 ARCOP ASSOCIATES PVT LTD
 Plot No. 36B, Sector-32, Institutional Area,
 Gurugram, Haryana, 122001, India
 Tel.: 91-124-4595500
 Fax: 91-124-4595550

ASSOCIATE ARCHITECTS
RISIMIS ARCHITECTS
 RMS ARCHITECTS PVT. LTD.
 69, Nara Niwas Bhawani Kunj
 (Behind D2), Vasant Kunj,
 New Delhi-110070.
 Tel.: 011-26898616, 26898617
 WWW.RISIMS-ARCH.COM

This is a PROVISIONAL BUILDING PLAN approved only for the purpose of obtaining objections from the governing authority.

Checked and found ok for Public Health (Civil) Service under no. 33643 dated 04/04/24 in Haryana under no. 33643 dated 04/04/24


Supervising Engineer (HO) for Engineering Services Haryana (Haryana)

TO BE READ WITH THE OFFICE DATED:

OWNER'S SEAL & SIGNATURE

ARCHITECTS SEAL & SIGNATURE

JAN-2024 Scale: 1:200 Drawing No.: 124624-1
 Drawing Title: SITE PLAN (SEWERAGE SUPPLY & IRRIGATION SCHEME) (STORM WATER SCHEME)

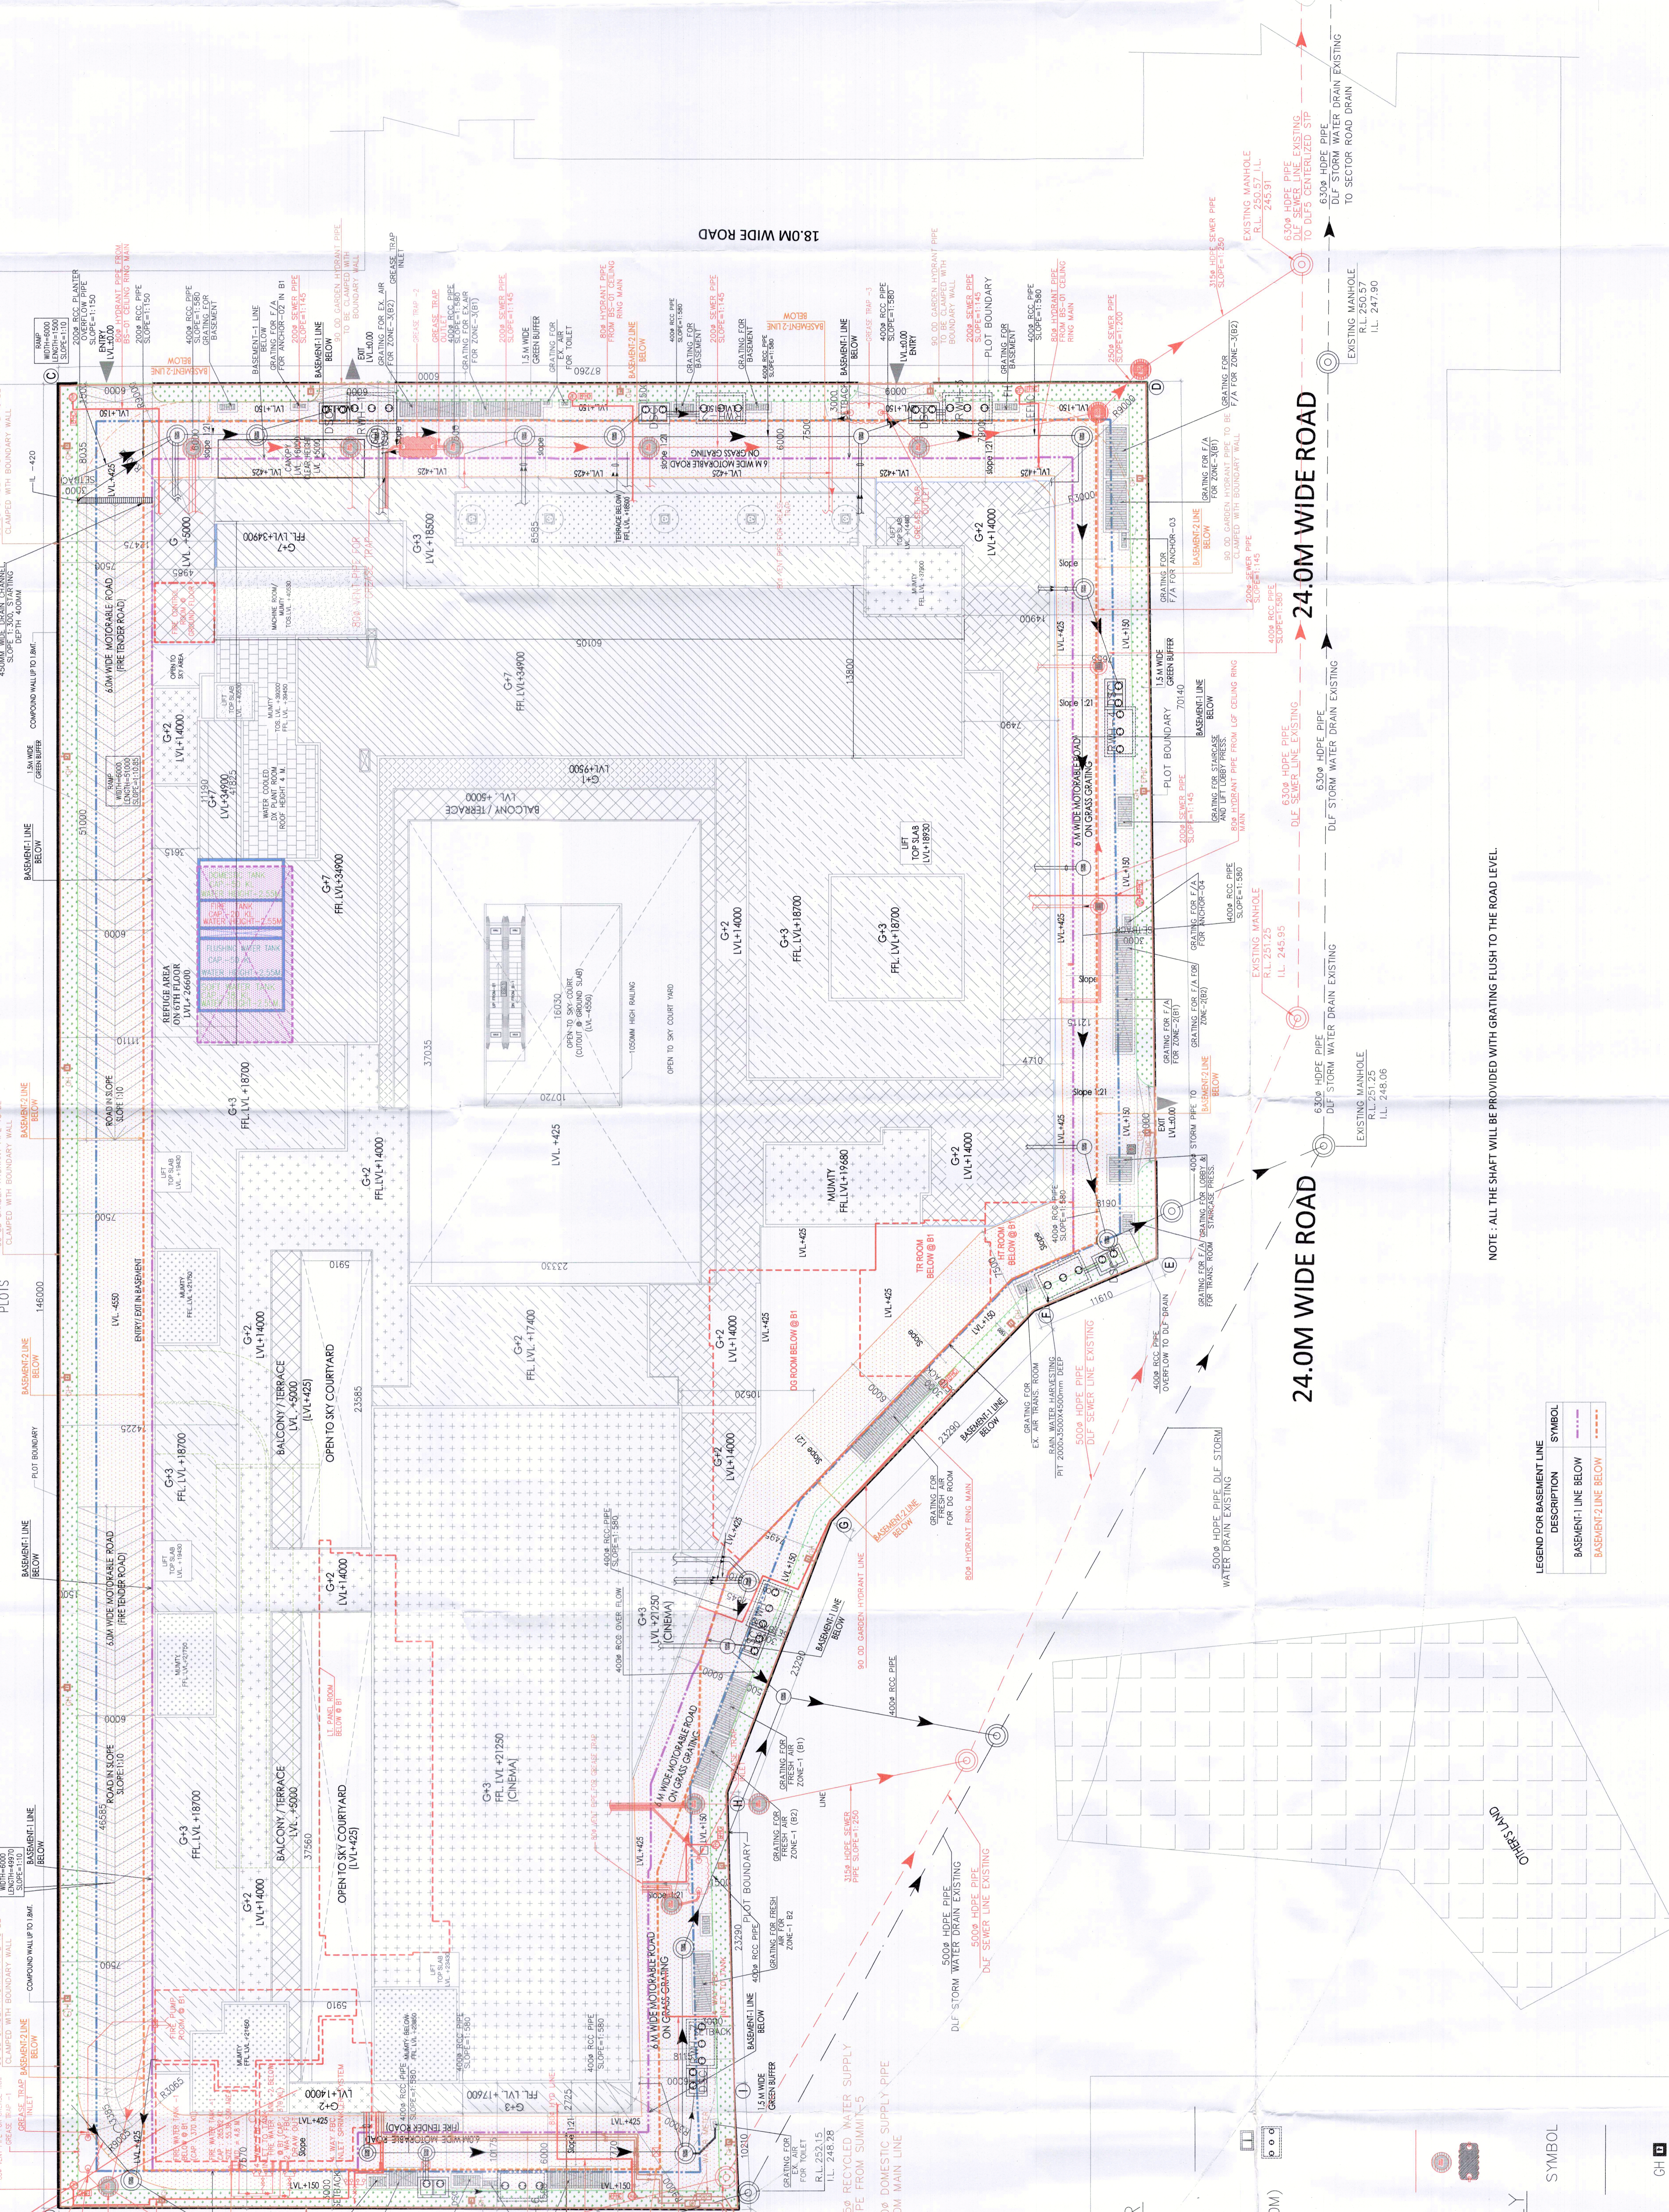

NOTE: ALL THE SHAFT WILL BE PROVIDED WITH GRATING FLUSH TO THE ROAD LEVEL.

LEGEND FOR BASEMENT LINE

DESCRIPTION	SYMBOL
BASEMENT LINE BELOW	---
BASEMENT LINE BELOW	---

LEGEND FOR STORM WATER

DESCRIPTION	SYMBOL
STORM WATER PIPE	---
STORM WATER MANHOLE (900ø/1200ø)	⊙
DE-SILTING CHAMBER (2.0X1.2M)	⊙
RAIN WATER HARVESTING PIT (3.5MX2.0M)	⊙

LEGEND FOR SEWERAGE

DESCRIPTION	SYMBOL
SEWER PIPE	---
SEWER MANHOLE (900/1200ø)	⊙
PRE-FABRICATED GREASE TRAP	⊙

LEGEND FOR WATER SUPPLY

DESCRIPTION	SYMBOL
DOMESTIC WATER SUPPLY PIPE	---
FUSHING WATER SUPPLY PIPE	---
GARDEN HYDRANT WATER SUPPLY PIPE	---
GARDEN HYDRANT VALVE	⊙
VALVE CHAMBER 900X900mm	WM

LEGEND FOR FIRE FIGHTING

DESCRIPTION	SYMBOL
EXTERNAL FIRE HYDRANT PIPE	---
EXTERNAL FIRE HYDRANT BUTTERFLY VALVE	FH
NON RETURN VALVE	⊙
EXTERNAL FIRE HOSE CABINET	EFHC